

WASHINGTON METROPOLITAN AREA TRANSIT AUTHORITY




GENERAL PLANS

PROPOSED HEAVY REPAIR & OVERHAUL FACILITY

PRINCE GEORGE'S COUNTY, MARYLAND
DECEMBER 2018

SHEET	TITLE
1	INDEX OF DRAWINGS
2	ARCHITECTURE – SITE PLAN
3	LANDSCAPE – SITE PLAN
4	LIGHTING PLAN – SITE PLAN
5	TRAFFIC CIRCULATION – SITE PLAN
6	OVERALL FIRST FLOOR PLAN – CTEM/TRST BUILDING
7	OVERALL SECOND/MEZZANINE FLOOR PLAN – CTEM/TRST BUILDING
8	BUILDING ELEVATIONS – 1 – CTRM/TRST BUILDING
9	BUILDING ELEVATIONS – 2 – CTRM/TRST BUILDING ELEVATIONS
10	BUILDING SECTIONS – 1 – CTRM/TRST BUILDING
11	BUILDING SECTIONS – 2 – CTRM/TRST BUILDING ELEVATIONS
12	GROUND LEVEL PLAN – CTEM/TRST AND HR&O PARKING GARAGE
13	SECOND LEVEL PLAN – CTEM/TRST AND HR&O PARKING GARAGE
14	THIRD LEVEL PLAN – CTEM/TRST AND HR&O PARKING GARAGE
15	FOURTH LEVEL PLAN – CTEM/TRST AND HR&O PARKING GARAGE
16	ELEVATIONS – CTEM/TRST AND HR&O PARKING GARAGE
17	HEAVY REPAIR & OVERHAUL FACILITY OVERALL ARCHITECTURE FIRST LEVEL PLAN
18	HEAVY REPAIR & OVERHAUL FACILITY OVERALL ARCHITECTURE SECOND LEVEL PLAN
19	HEAVY REPAIR & OVERHAUL FACILITY OVERALL ARCHITECTURE ROOF LEVEL PLAN
20	HEAVY REPAIR & OVERHAUL FACILITY ARCHITECTURE - ELEVATIONS
21	HEAVY REPAIR & OVERHAUL FACILITY ARCHITECTURE ELEVATIONS
22	HEAVY REPAIR & OVERHAUL FACILITY ARCHITECTURE ELEVATIONS
23	HEAVY REPAIR & OVERHAUL FACILITY ARCHITECTURE – CROSS SECTIONS
24	HEAVY REPAIR & OVERHAUL FACILITY ARCHITECTURE LONG SECTIONS

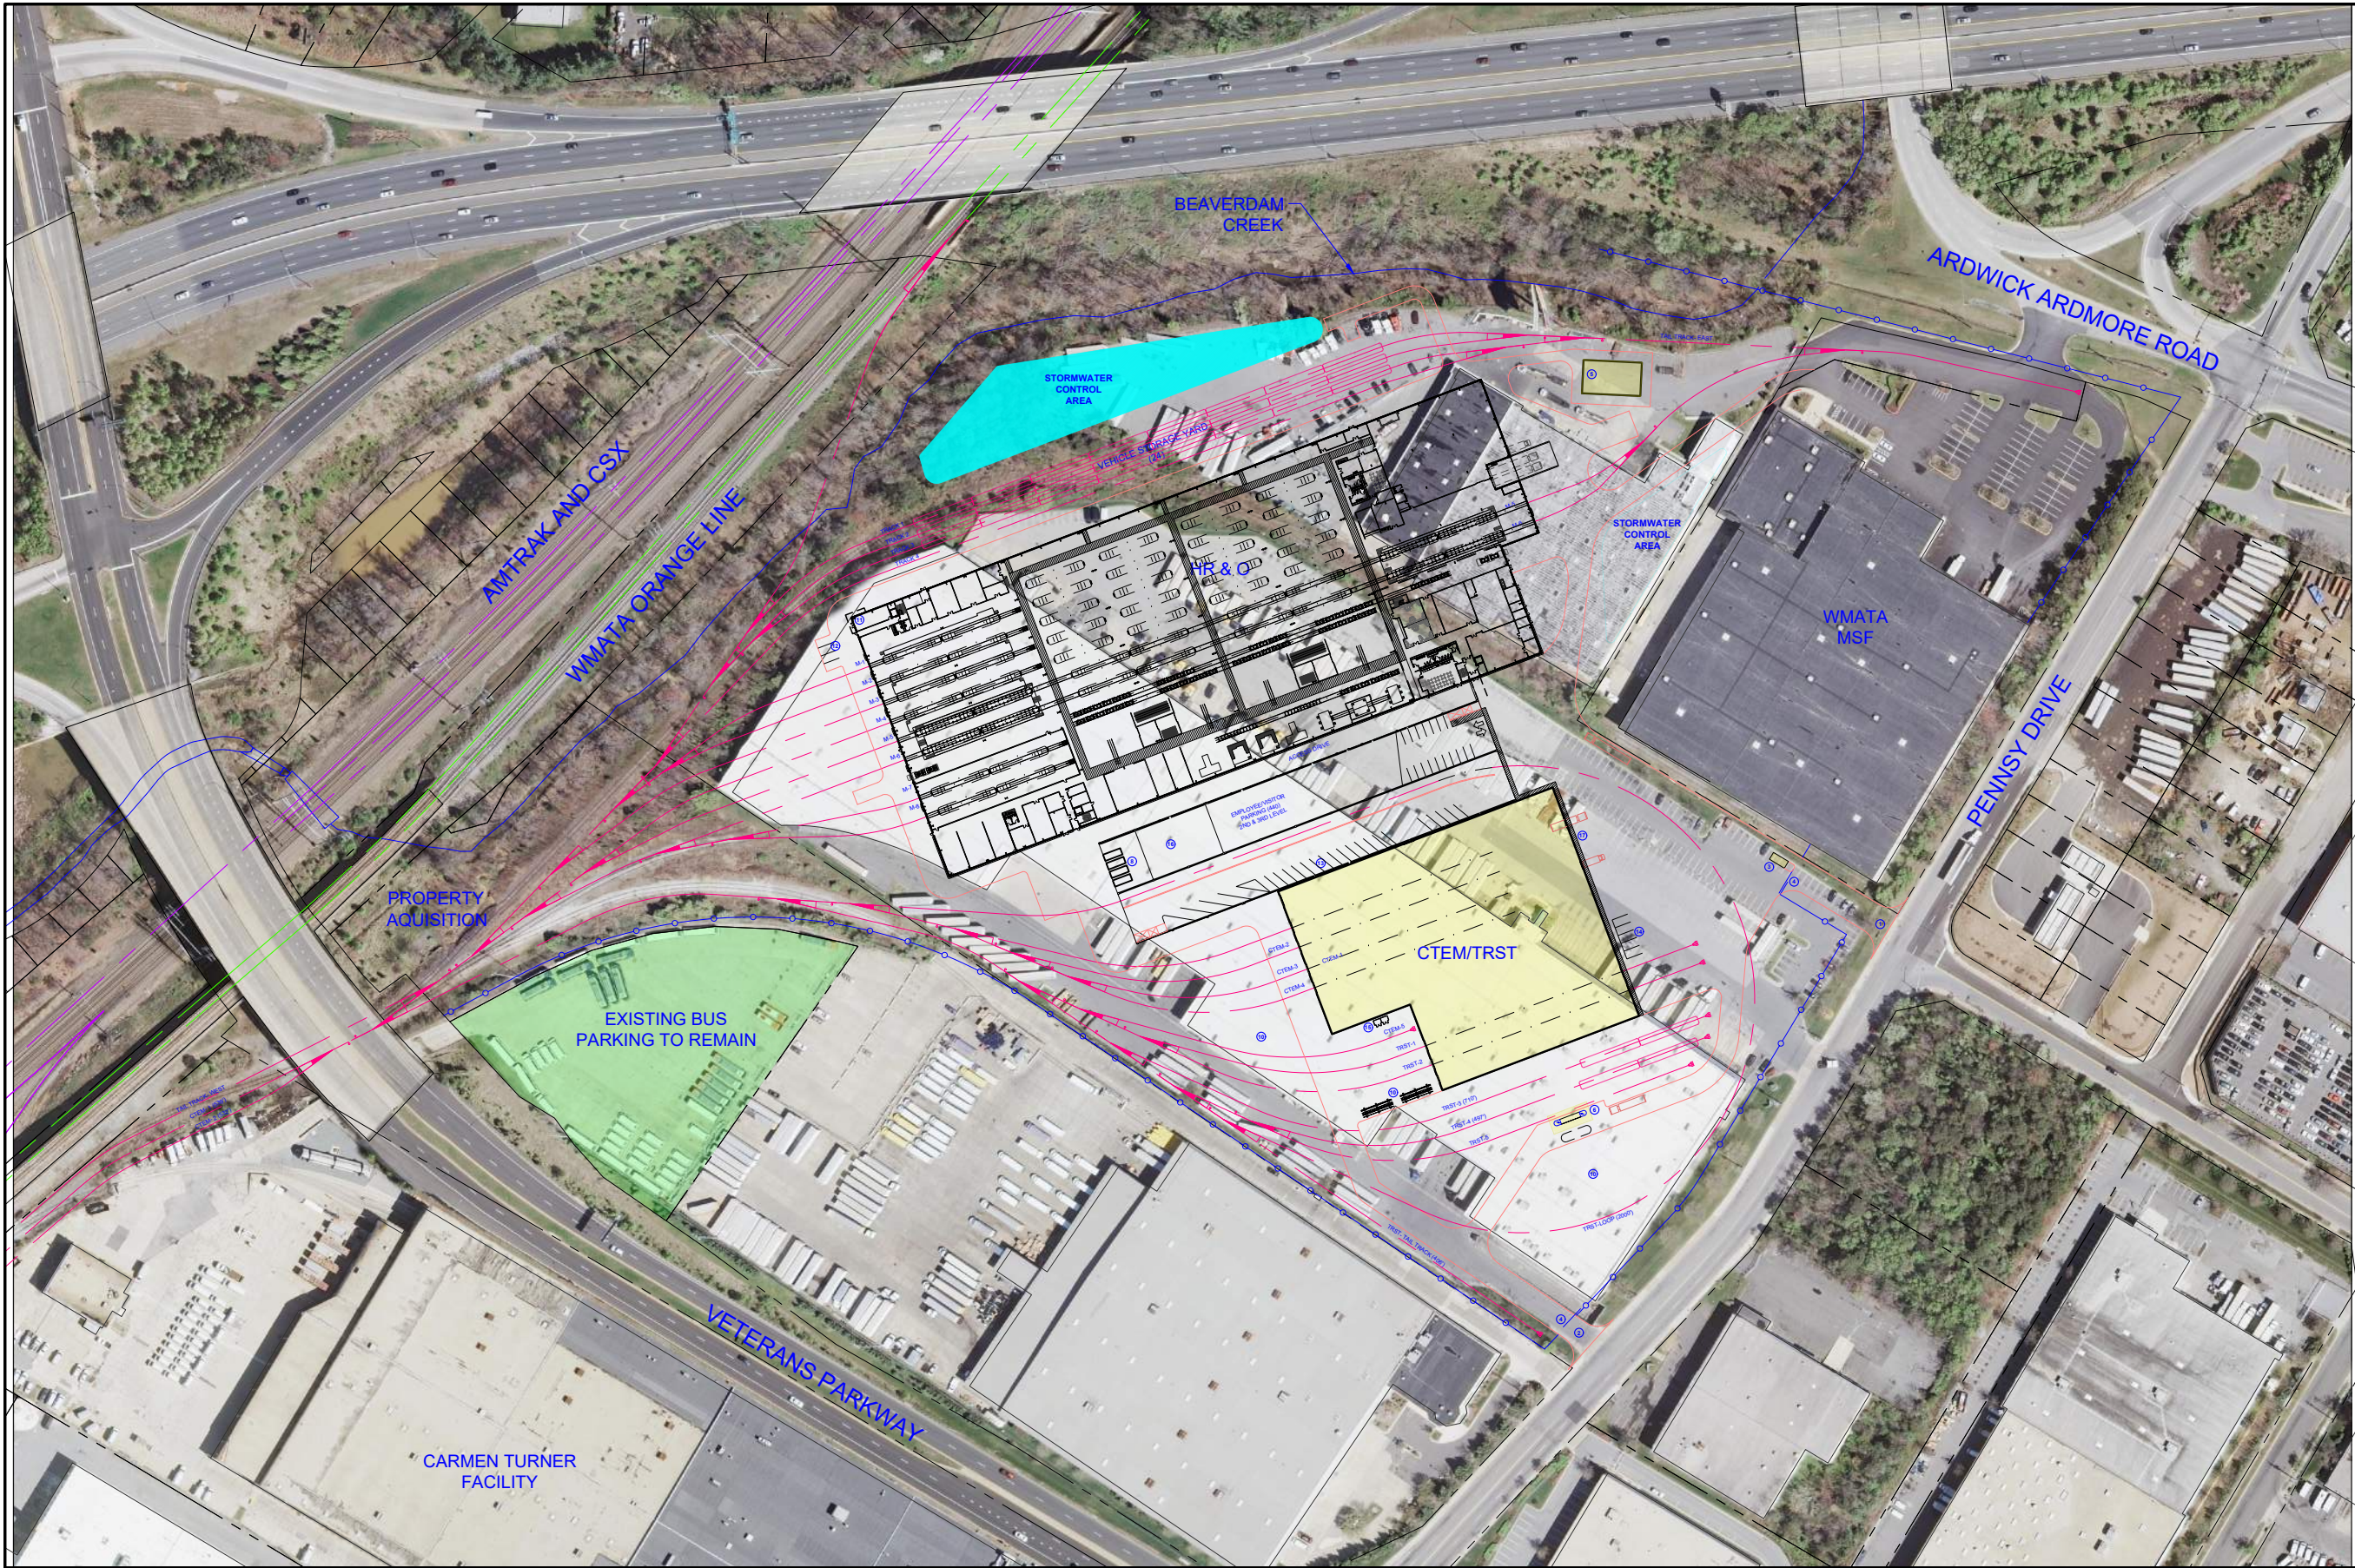

- NUMBERED NOTES
- ① MAIN FACILITY ENTRANCE EXIT
 - ② DUMPSTER AREAS METAL TRASH REC. CLING
 - ③ BALLAST AREA- OPEN
 - ④ TRACK STORAGE AREA- OPEN
 - ⑤ CONTROL TOWER- 2ND STOR. IN HR. Q BUILDING
 - ⑥ CONTROL TOWER EMPLOYEE PARKING
 - ⑦ CTEM NON-REVENUE VEHICLE PARKING
 - ⑧ TRST NON-REVENUE VEHICLE PARKING
 - ⑨ HA- ARDUOUS MATERIALS AND GAS STORAGE
 - ⑩ HS- Q WHEEL BLANK STORAGE AREA
 - ⑪ PEDESTRIAN CIRCULATION PATH

DESIGNED	ASI	9-21-2018
	DATE	
DRAWN	AH	9-21-2018
	DATE	
CHECKED	MNG	9-21-2018
	DATE	
APPROVED	ASI	9-21-2018
	DATE	

REFERENCE DRAWINGS	
NUMBER	DESCRIPTION

REVISIONS		
DATE	BY	DESCRIPTION

wsp


WSP USA
TWO GATEWAY CENTER
SUITE 1000
NEWARK, NEW JERSEY 07102

WASHINGTON METROPOLITAN AREA TRANSIT AUTHORITY


DEPARTMENT OF TRANSIT INFRASTRUCTURE AND ENGINEERING SERVICES
OFFICE OF MAJOR CAPITAL PROJECTS

SUBMITTED	9/21/2018	APPROVED
	DATE	CHIEF ENGINEER
		DATE

HEAVY REPAIR & OVERHAUL FACILITY	
ARCHITECTURE - SITE PLAN	
PENNSY DRIVE	
SCALE 1" = 100'-0"	DRAWING NO. G-002
SHEET NO. 2 of 24	

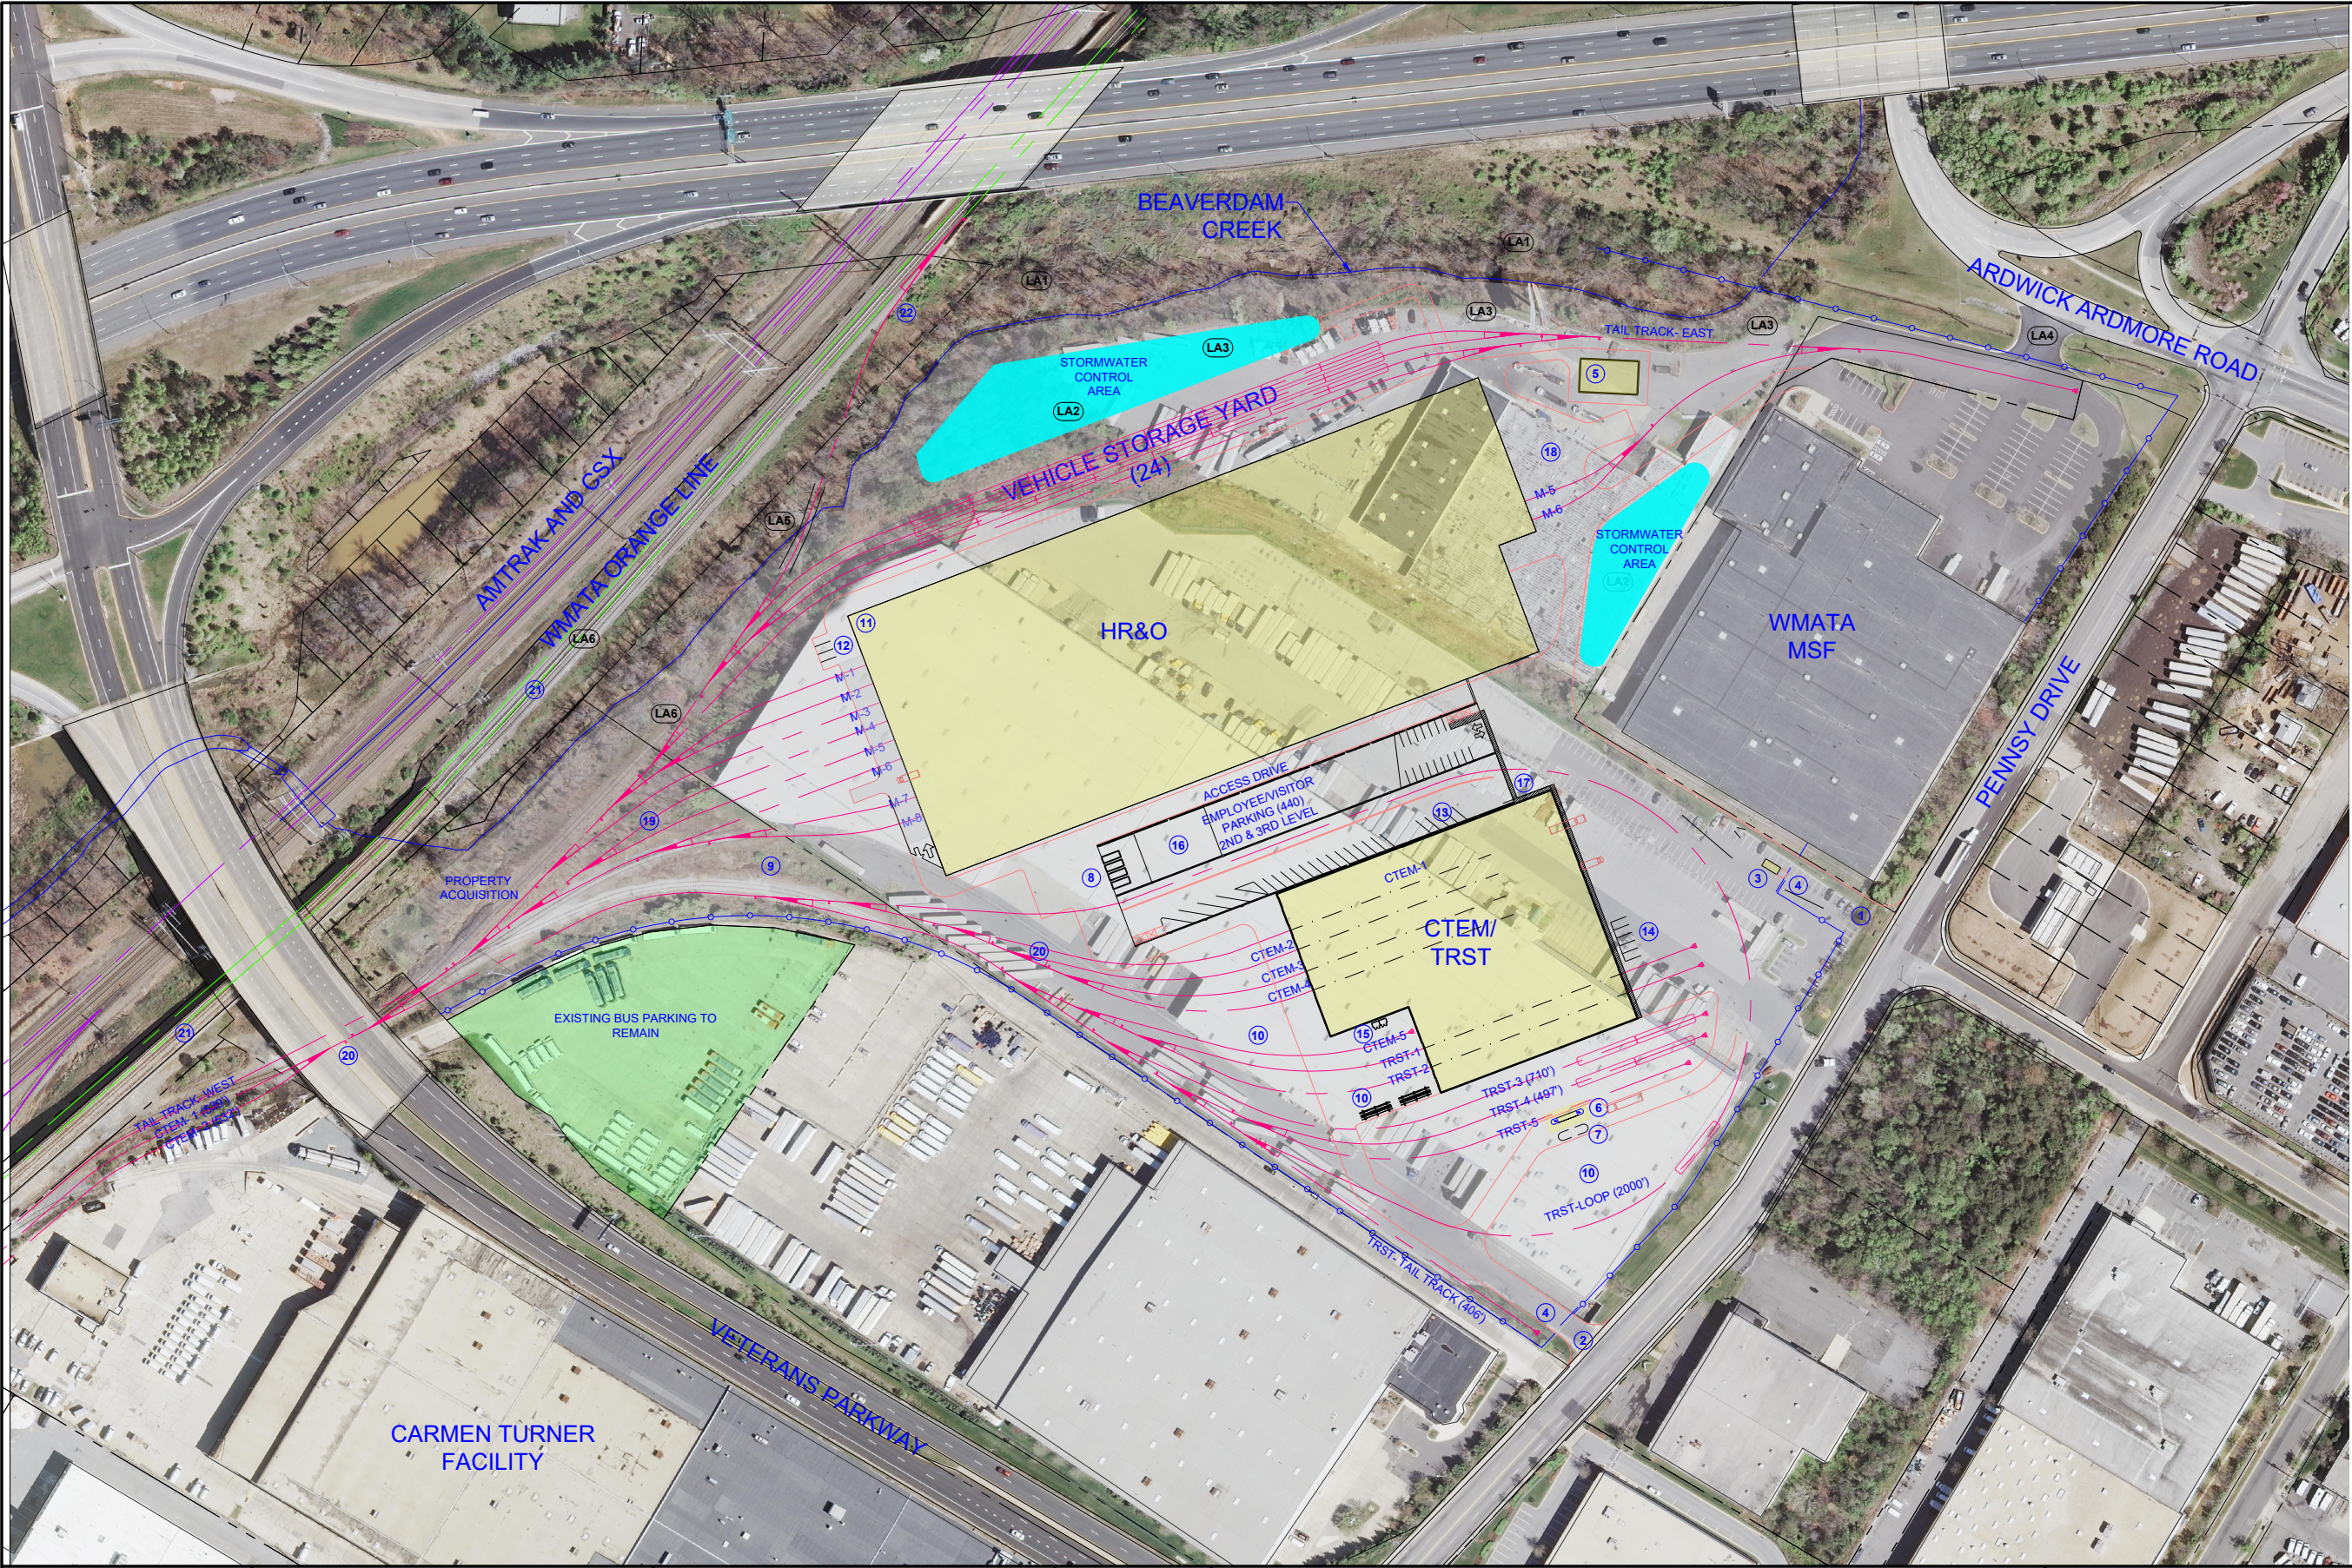

- LANDSCAPE NUMBERED NOTES
- LA1 WETLANDS AREA TO REMAIN
 - LA2 STORMWATER CONTROL AREA
 - LA3 REDUCTION OF PAVING AREA ADJACENT TO THE CREEK
 - LA4 REMOVED ARDWICK ARDMORE STREET ACCESS- NEW GRASS
 - LA5 MINIMAL IMPACT AT MAINLINE CONNECTION
 - LA6 EXISTING TRACK

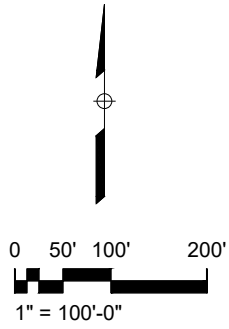

CONTRACT NO.
XXXXXXX

DESIGNED	10/12/18
DATE	10/12/18
DRAWN	10/12/18
DATE	10/12/18
CHECKED	10/12/18
DATE	10/12/18
APPROVED	10/12/18
DATE	10/12/18

REFERENCE DRAWINGS	
NUMBER	DESCRIPTION

REVISIONS		
DATE	BY	DESCRIPTION

WASHINGTON METROPOLITAN AREA TRANSIT AUTHORITY
DEPARTMENT OF TRANSIT INFRASTRUCTURE AND ENGINEERING SERVICES
OFFICE OF MAJOR CAPITAL PROJECTS


SUBMITTED _____ DATE _____ APPROVED _____ DATE _____
CHIEF ENGINEER

PENNSY DRIVE RAIL MAINTENANCE FACILITY
LANDSCAPE - SITE PLAN
PENNSY DRIVE

SCALE
1" = 100'-0"

DRAWING NO.
G-005

SHEET NO.
3 of 24

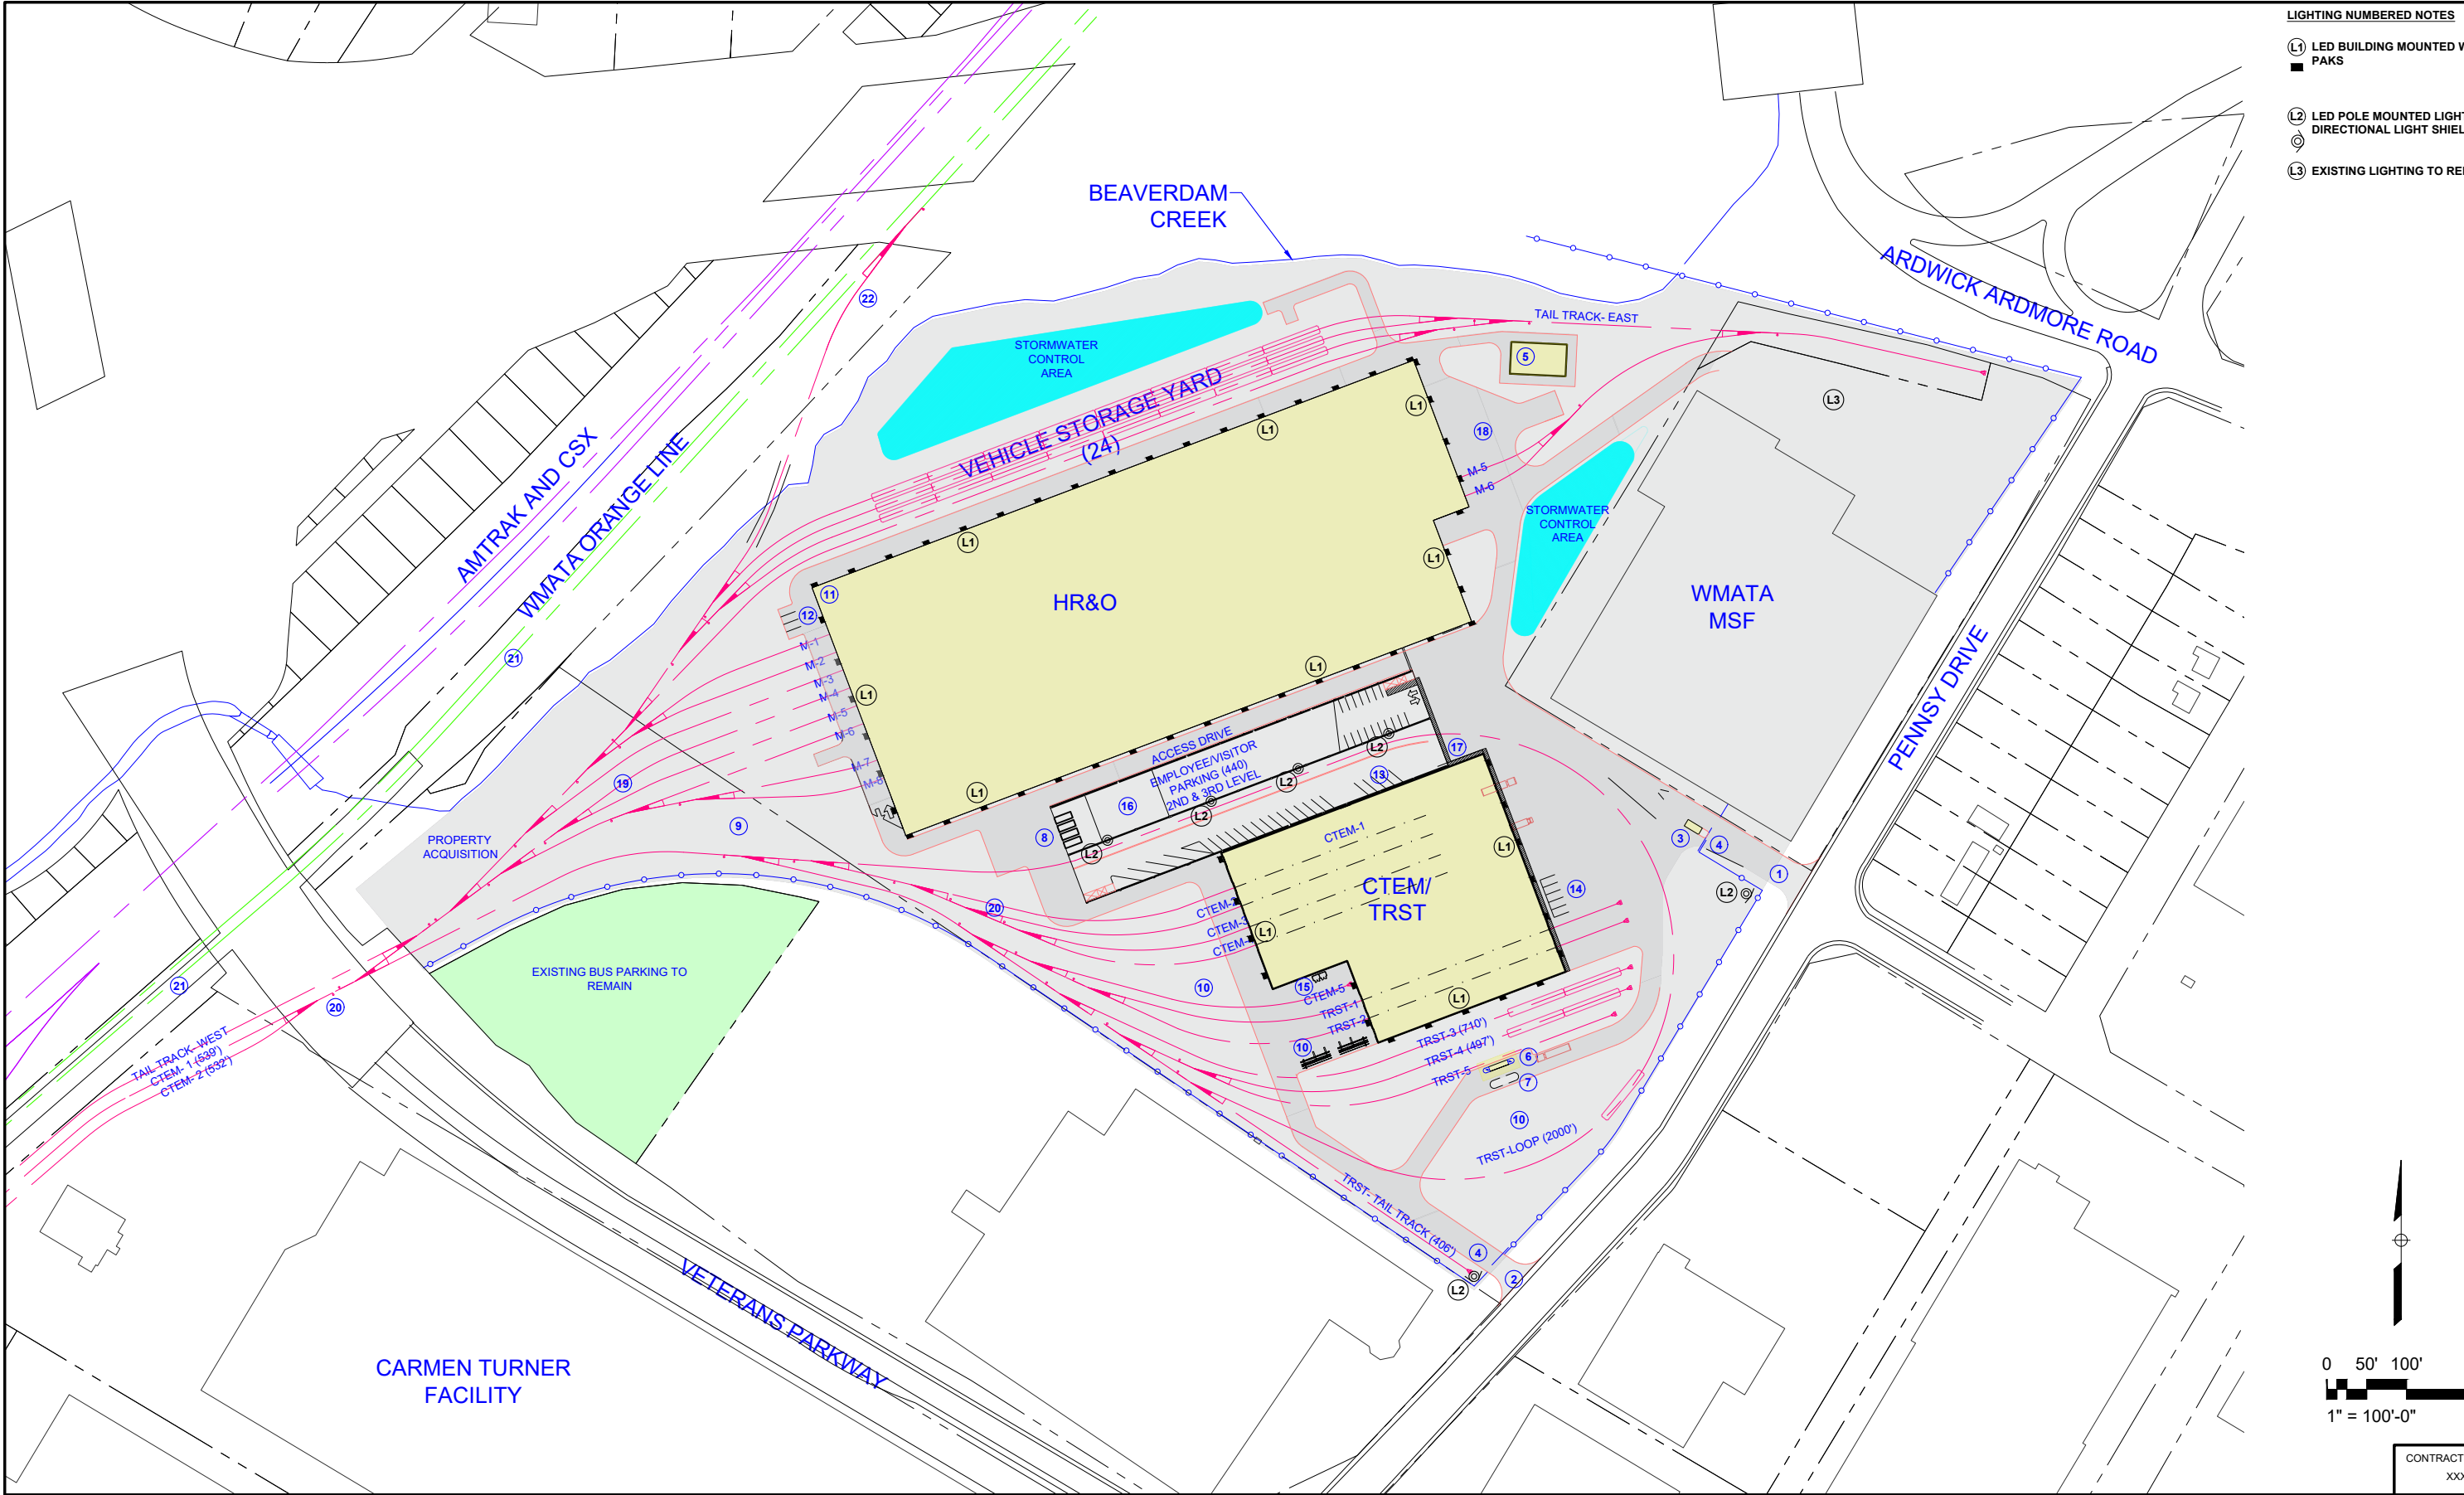

LIGHTING NUMBERED NOTES

- (L1) LED BUILDING MOUNTED WALL PAKS
- (L2) LED POLE MOUNTED LIGHTS W/ DIRECTIONAL LIGHT SHIELD
- (L3) EXISTING LIGHTING TO REMAIN

DESIGNED	10/12/18
DATE	10/12/18
DRAWN	10/12/18
DATE	10/12/18
CHECKED	10/12/18
DATE	10/12/18
APPROVED	10/12/18
DATE	10/12/18

REFERENCE DRAWINGS	
NUMBER	DESCRIPTION

REVISIONS		
DATE	BY	DESCRIPTION

WASHINGTON METROPOLITAN AREA TRANSIT AUTHORITY

DEPARTMENT OF TRANSIT INFRASTRUCTURE AND ENGINEERING SERVICES
OFFICE OF MAJOR CAPITAL PROJECTS

SUBMITTED _____ DATE _____

APPROVED _____
CHIEF ENGINEER DATE _____


PENNSY DRIVE RAIL MAINTENANCE FACILITY

LIGHTING PLAN - SITE PLAN
PENNSY DRIVE


SCALE
1" = 100'-0"

DRAWING NO.
G-006


SHEET NO.
4 of 24

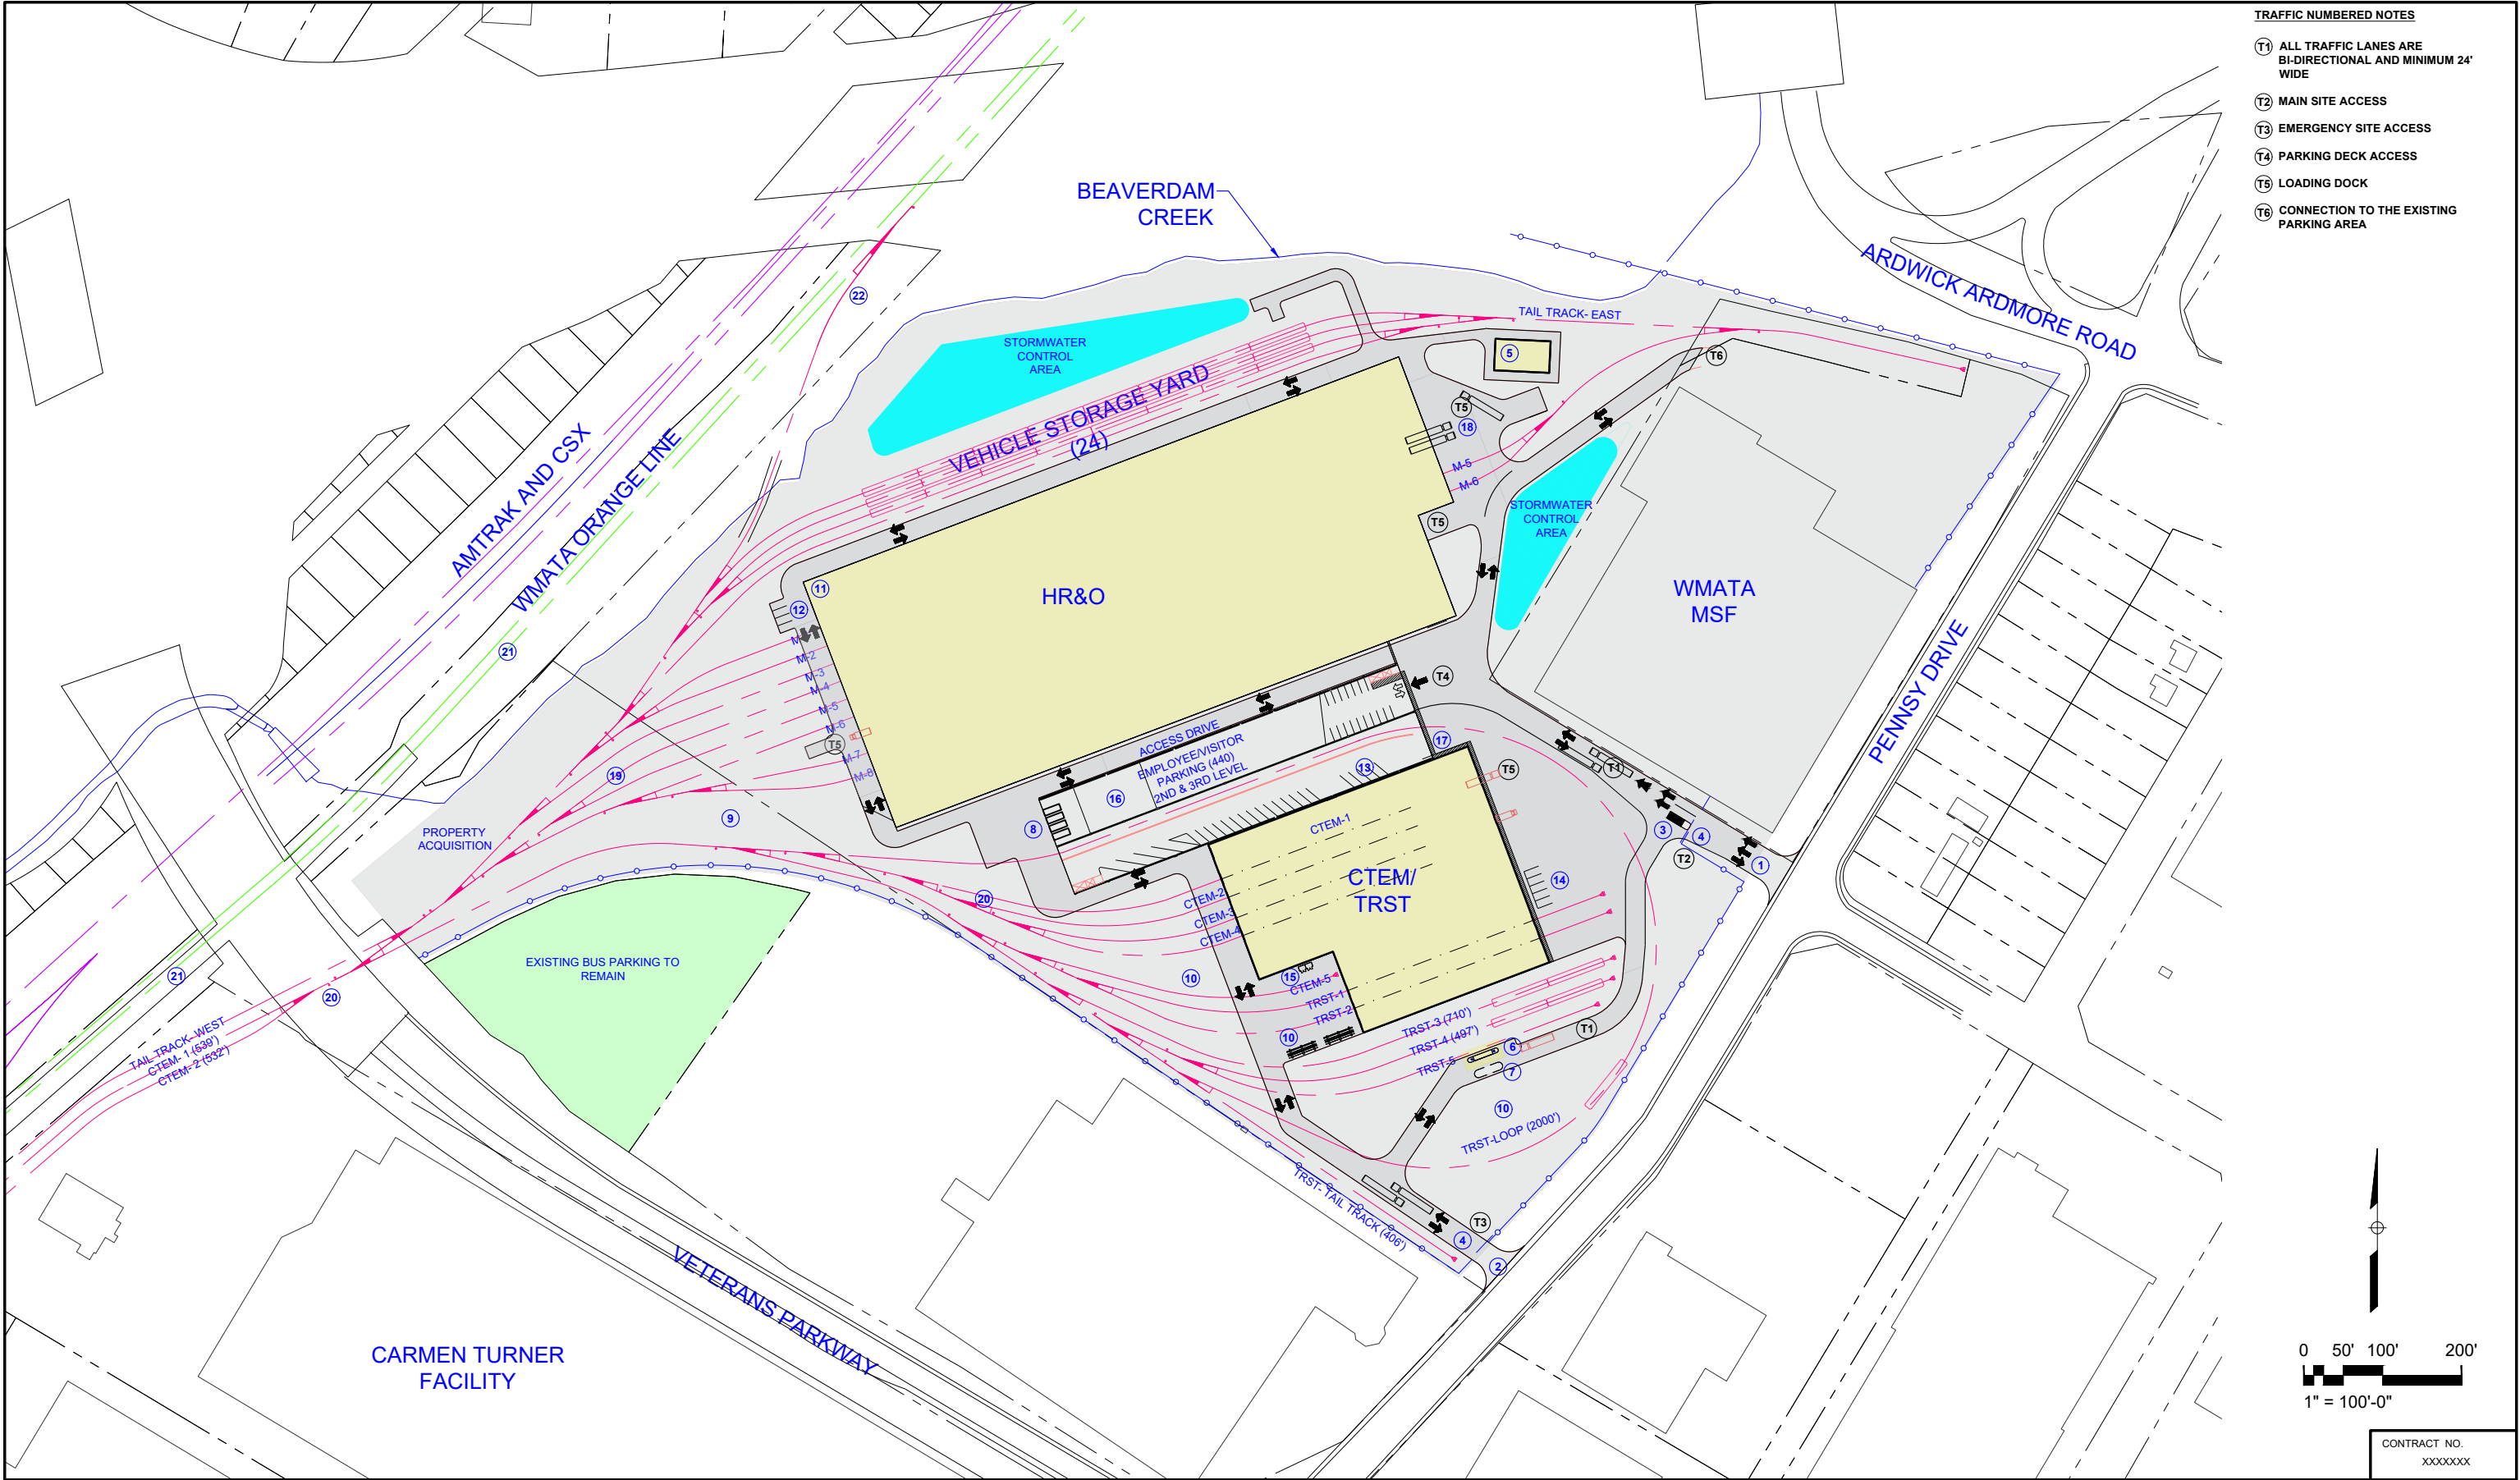

DESIGNED _____ 10/12/18 DATE DRAWN _____ 10/12/18 DATE CHECKED _____ 10/12/18 DATE APPROVED _____ 10/12/18 DATE		REFERENCE DRAWINGS		REVISIONS			WASHINGTON METROPOLITAN AREA TRANSIT AUTHORITY DEPARTMENT OF TRANSIT INFRASTRUCTURE AND ENGINEERING SERVICES OFFICE OF MAJOR CAPITAL PROJECTS SUBMITTED _____ DATE _____ APPROVED _____ CHIEF ENGINEER _____ DATE _____	PENNSY DRIVE RAIL MAINTENANCE FACILITY TRAFFIC CIRCULATION - SITE PLAN PENNSY DRIVE		
		NUMBER	DESCRIPTION	DATE	BY	DESCRIPTION		SCALE 1" = 100'-0"	DRAWING NO. G-007	SHEET NO. 5 of 24


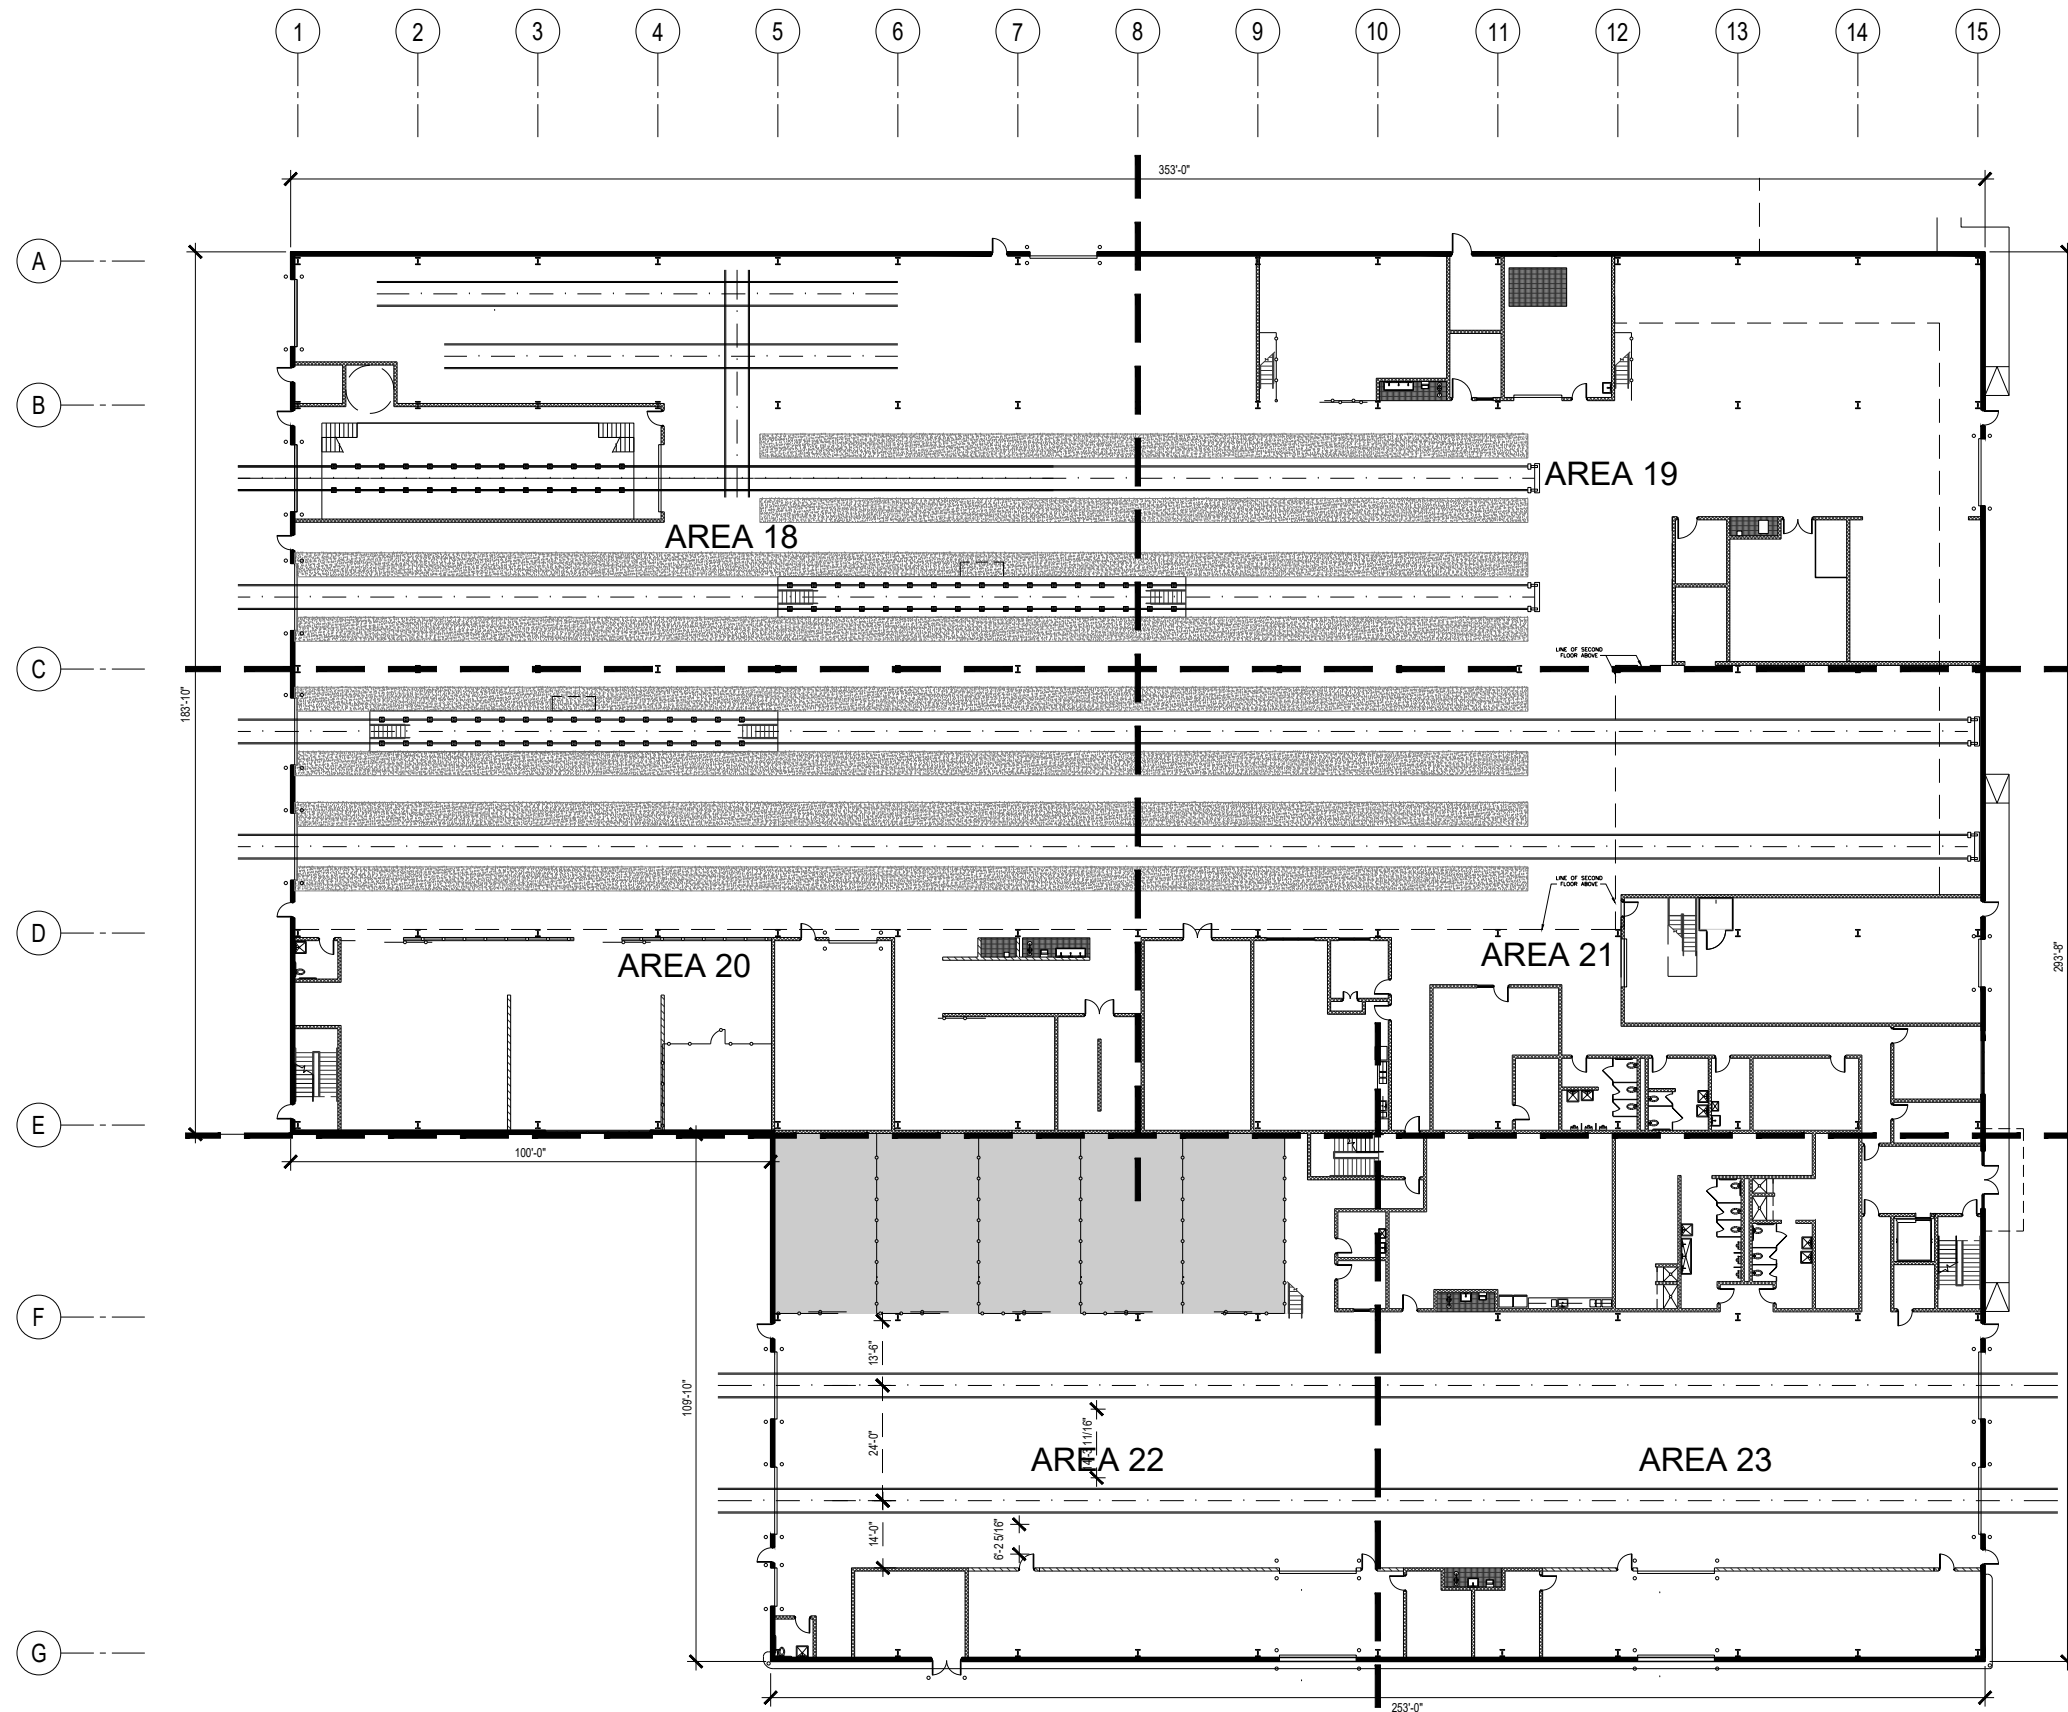


AREA 18	AREA 19
AREA 20	AREA 21
AREA 22	AREA 23

 

CONTRACT NO.
XXXXXXX

DESIGNED ASI 10/12/18 DATE 10/12/18 DRAWN RR 10/12/18 DATE 10/12/18 CHECKED MNG 10/12/18 DATE 10/12/18 APPROVED ASI 10/12/18 DATE 10/12/18	REFERENCE DRAWINGS		REVISIONS			WASHINGTON METROPOLITAN TRANSIT AUTHORITY DEPARTMENT OF TRANSIT INFRASTRUCTURE AND ENGINEERING SERVICES OFFICE OF MAJOR CAPITAL PROJECTS SUBMITTED _____ DATE _____ APPROVED _____ CHIEF ENGINEER _____ DATE _____	PENNSY DRIVE RAIL MAINTENANCE FACILITY OVERALL FIRST FLOOR PLAN – CTM/TRST BUILDING		
	NUMBER	DESCRIPTION	DATE	BY	DESCRIPTION		SCALE 1" = 20'-0"	DRAWING NO. CT-A-100	SHEET NO. 6 of 24

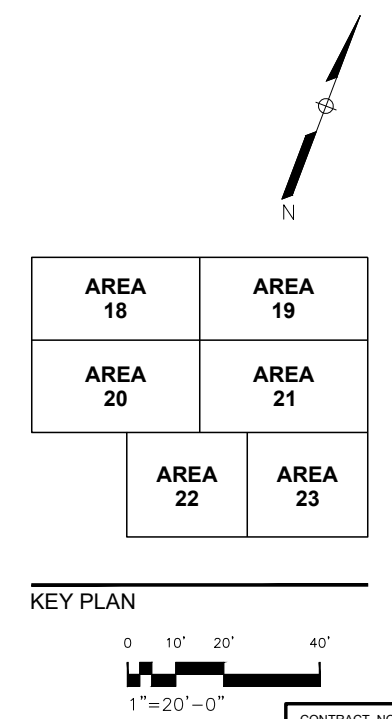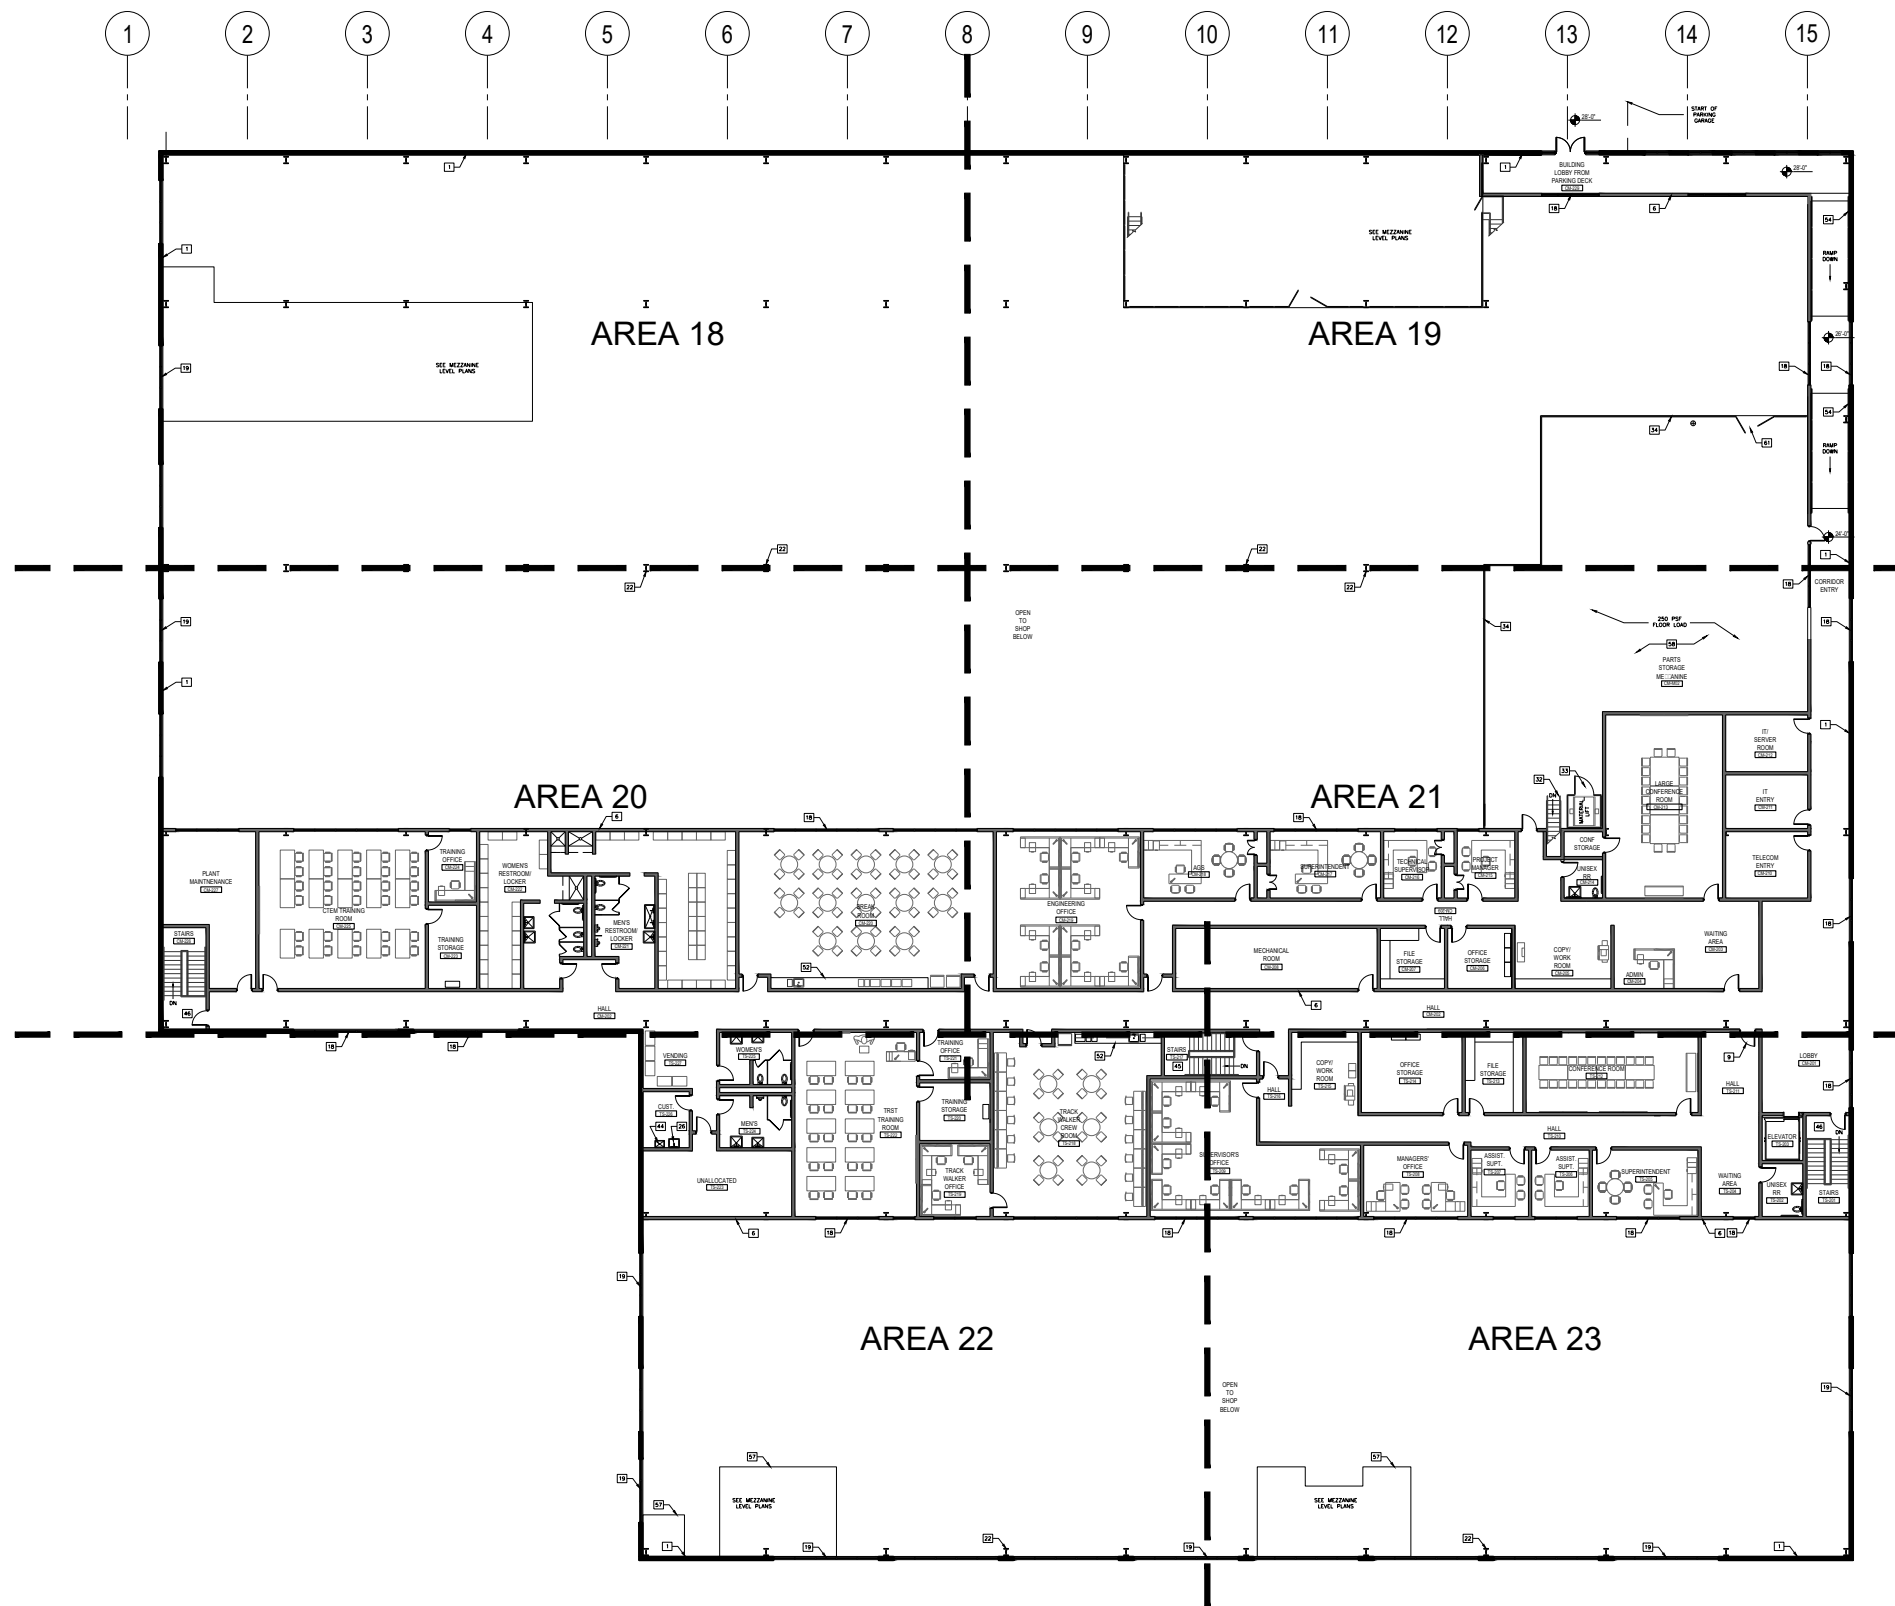

DESIGNED	ASI	10/12/18
		DATE
DRAWN	RR	10/12/18
		DATE
CHECKED	MNG	10/12/18
		DATE
APPROVED	ASI	10/12/18
		DATE




REFERENCE DRAWINGS	
NUMBER	DESCRIPTION

REVISIONS		
DATE	BY	DESCRIPTION




WASHINGTON METROPOLITAN TRANSIT AUTHORITY	
DEPARTMENT OF TRANSIT INFRASTRUCTURE AND ENGINEERING SERVICES	
OFFICE OF MAJOR CAPITAL PROJECTS	
SUBMITTED	DATE
APPROVED	DATE
CHIEF ENGINEER	

PENNSY DRIVE RAIL MAINTENANCE FACILITY		
OVERALL FIRST FLOOR PLAN –		
CTEM/TRST BUILDING		
SCALE	DRAWING NO.	SHEET NO.
1" = 20'-0"	CT-A-150	7 of 24

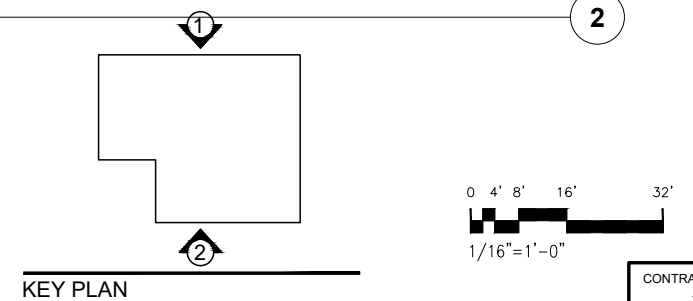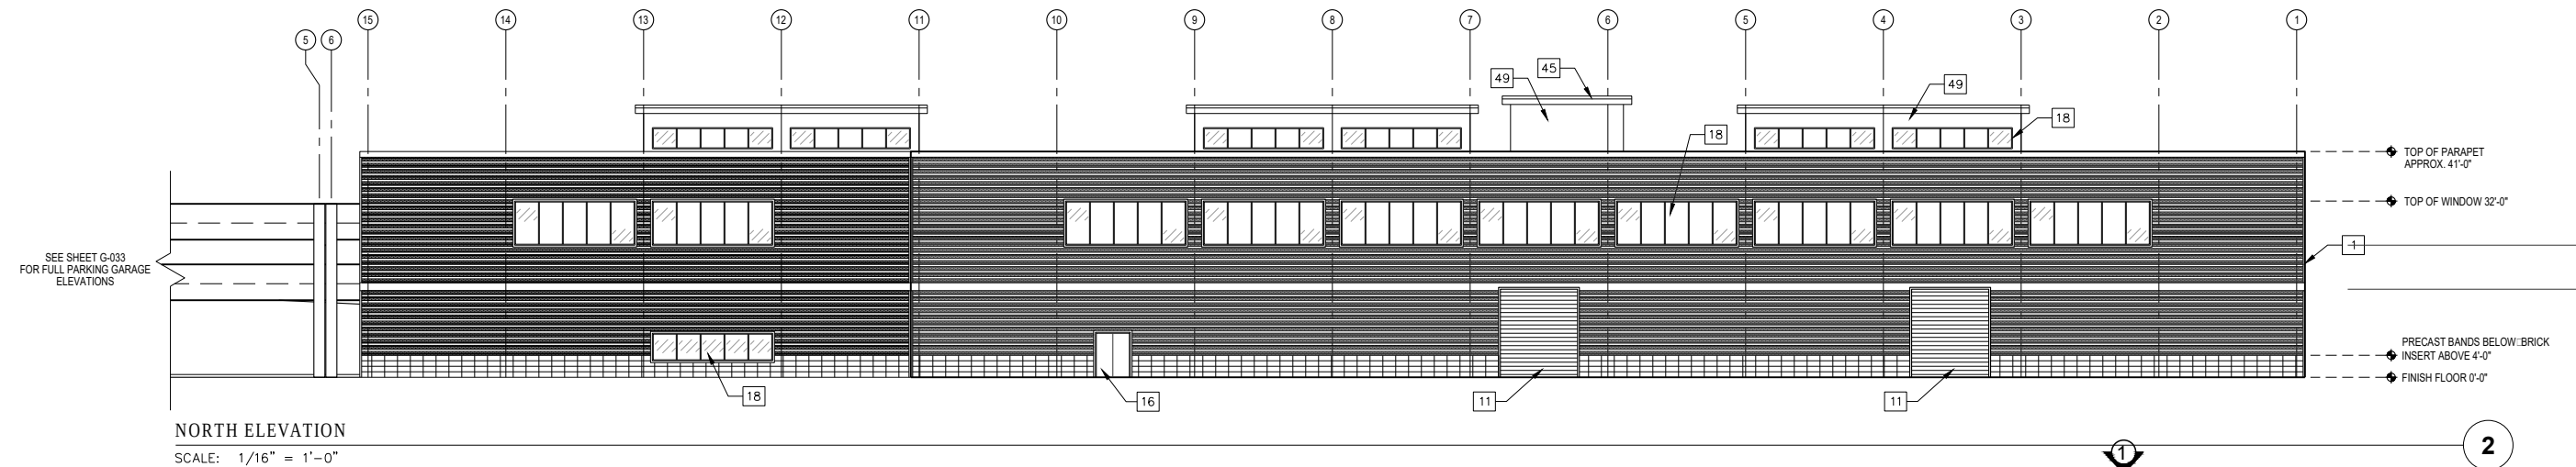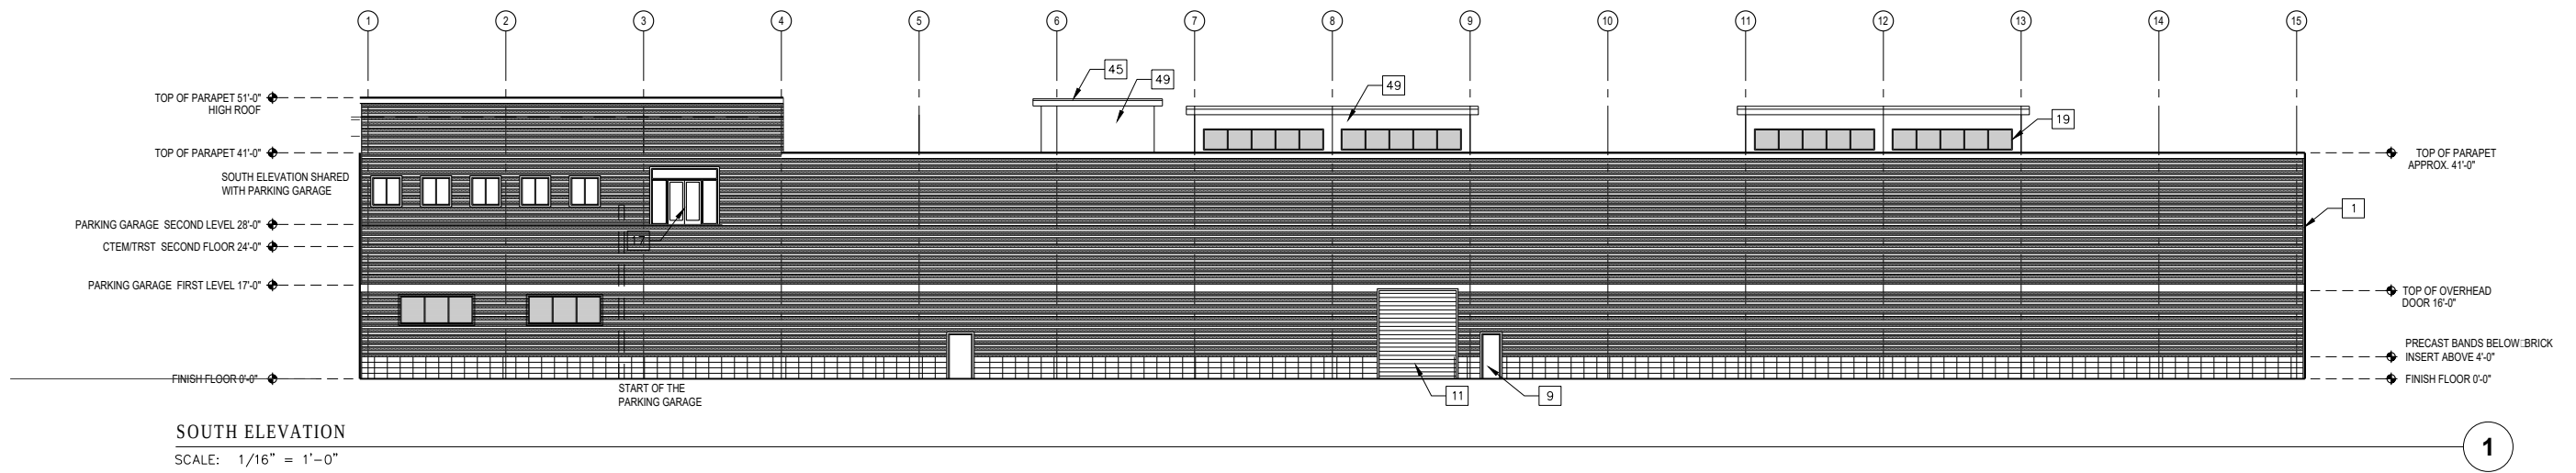


DESIGNEDASI10/12/18DATE DRAWNRR10/12/18DATE CHECKEDMNG10/12/18DATE APPROVEDASI10/12/18DATE	REFERENCE DRAWINGS		REVISIONS			WASHINGTON METROPOLITAN TRANSIT AUTHORITY DEPARTMENT OF TRANSIT INFRASTRUCTURE AND ENGINEERING SERVICES OFFICE OF MAJOR CAPITAL PROJECTS SUBMITTEDDATE APPROVEDCHIEF ENGINEERDATE	PENNSY DRIVE RAIL MAINTENANCE FACILITY		
	NUMBER	DESCRIPTION	DATE	BY	DESCRIPTION		BUILDING ELEVATIONS – 1 –		
							CTR/MTST BUILDING		
							SCALE1/16" = 1'-0"		
							DRAWING NO. A-201		
							SHEET NO. 8 of 24		

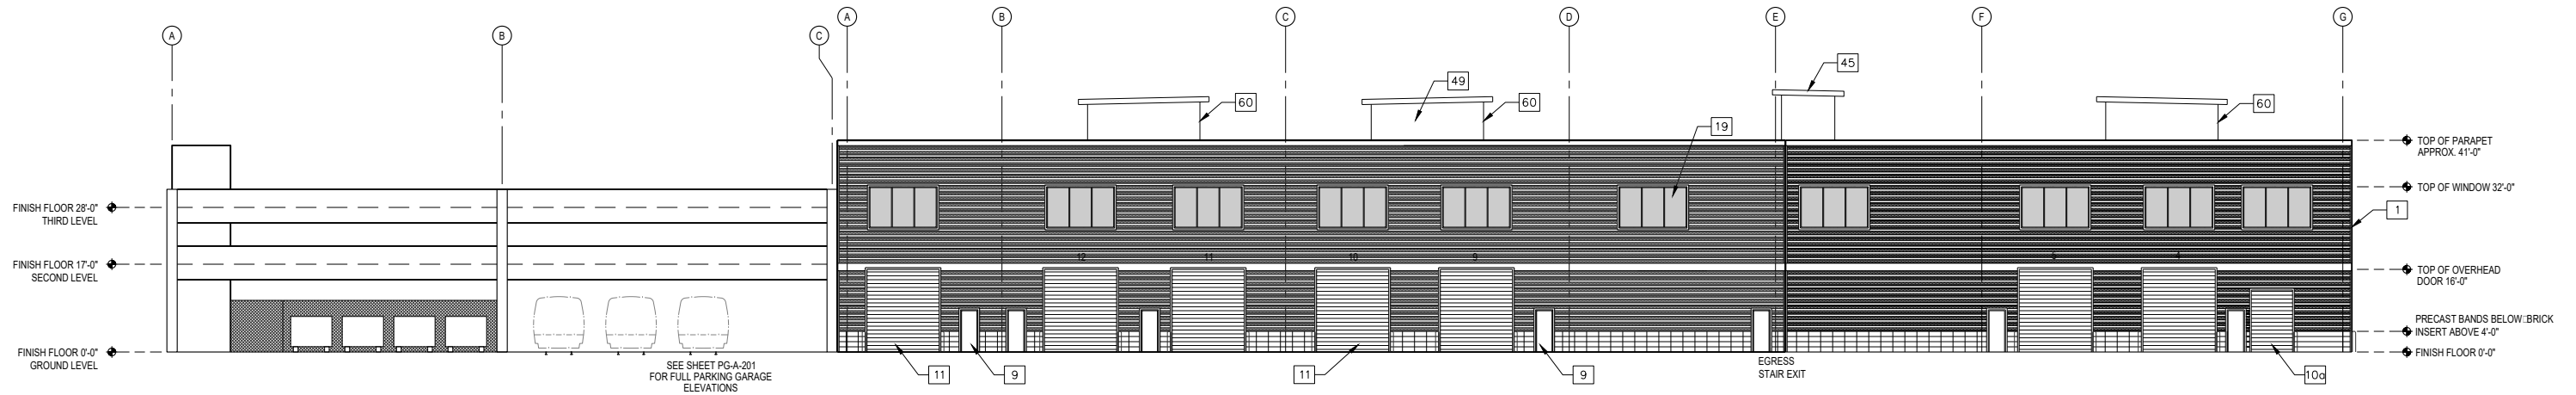

EAST ELEVATION

SCALE: 1/16" = 1'-0"


1

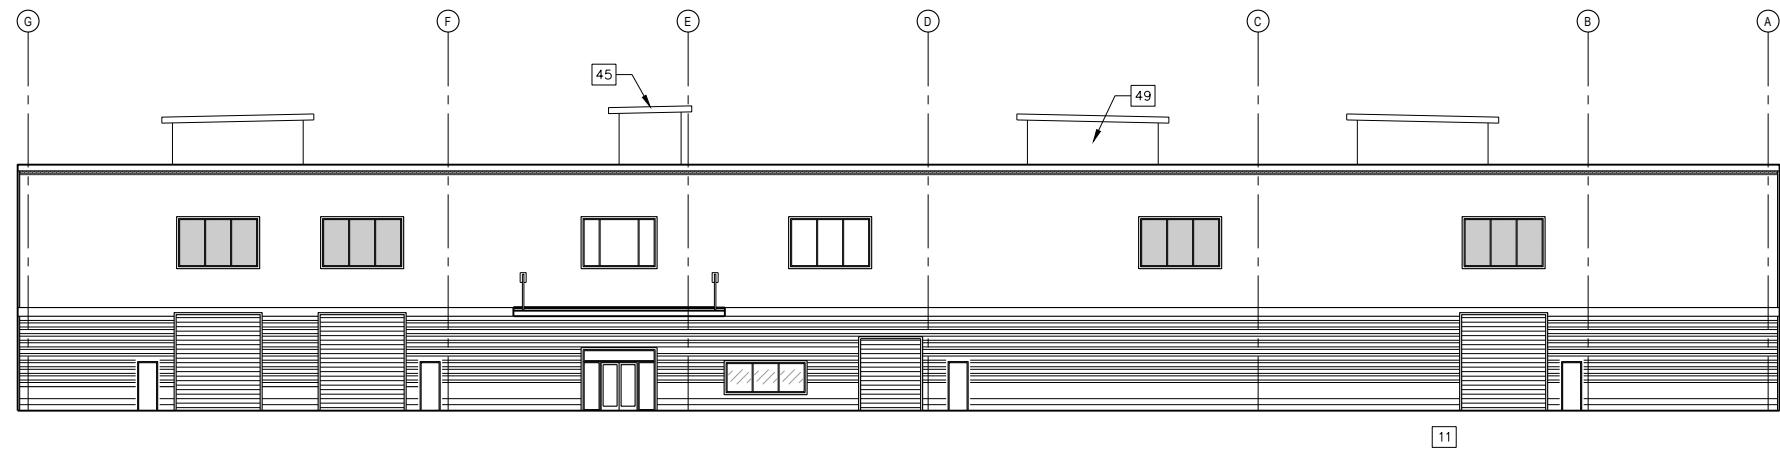

WEST ELEVATION

SCALE: 1/16" = 1'-0"




2

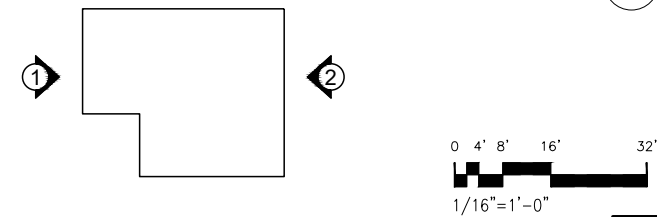

KEY PLAN

CONTRACT NO.
XXXXXXX

DESIGNEDASI10/12/18 DATE DRAWNRR10/12/18 DATE CHECKEDMNG10/12/18 DATE APPROVEDASI10/12/18 DATE	REFERENCE DRAWINGS		REVISIONS			WASHINGTON METROPOLITAN TRANSIT AUTHORITY DEPARTMENT OF TRANSIT INFRASTRUCTURE AND ENGINEERING SERVICES OFFICE OF MAJOR CAPITAL PROJECTS SUBMITTEDDATEAPPROVED CHIEF ENGINEERDATE	PENNSY DRIVE RAIL MAINTENANCE FACILITY BUILDING ELEVATIONS – 2 – CTRM/TRST BUILDING ELEVATIONS		
	NUMBER	DESCRIPTION	DATE	BY	DESCRIPTION		SCALE 1/16" = 1'-0"	DRAWING NO. A-202	SHEET NO. 9 of 24

 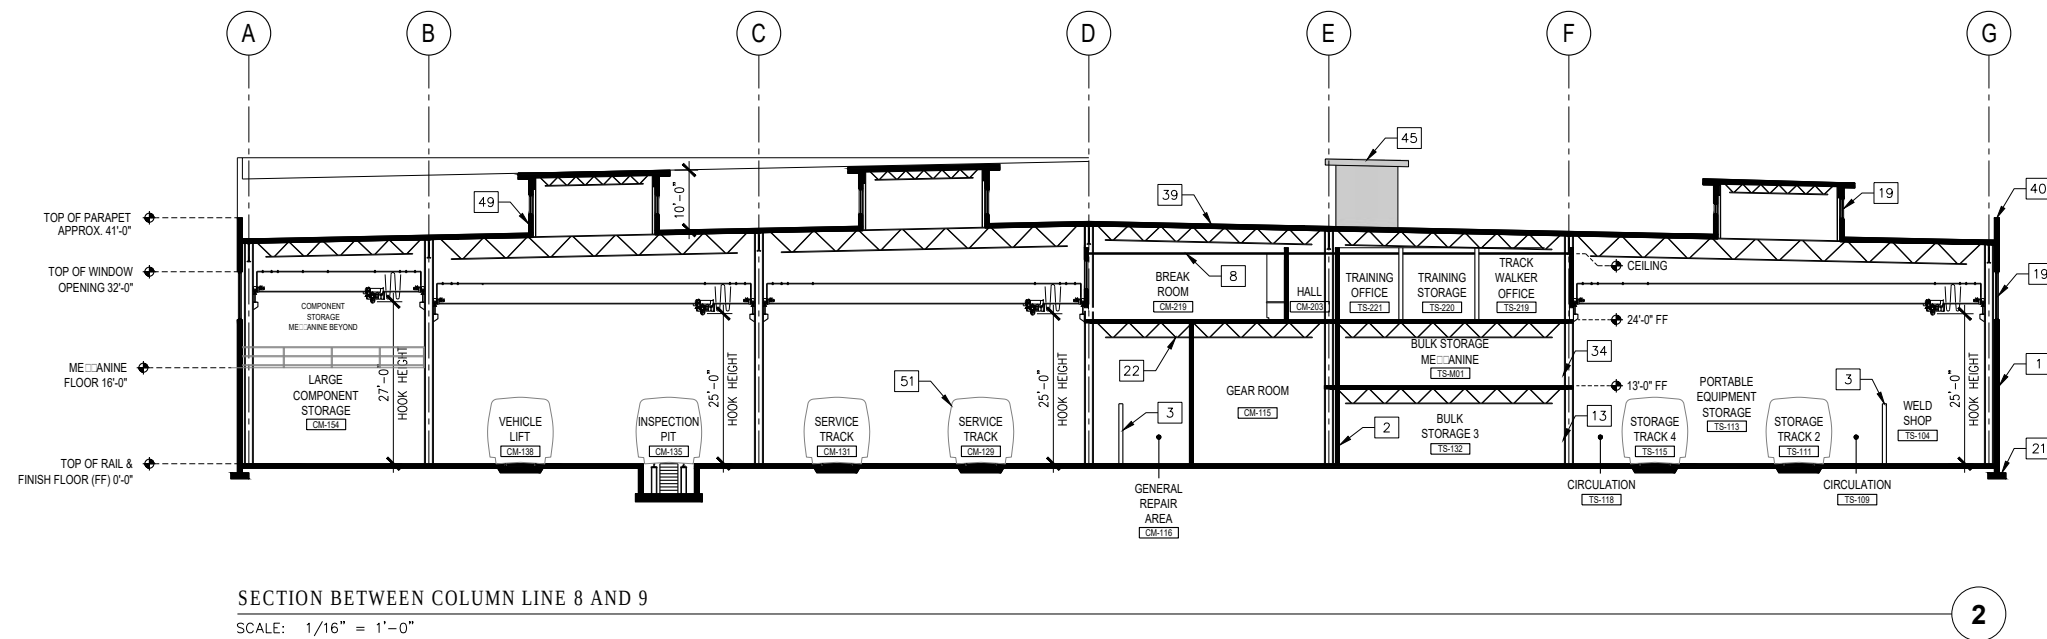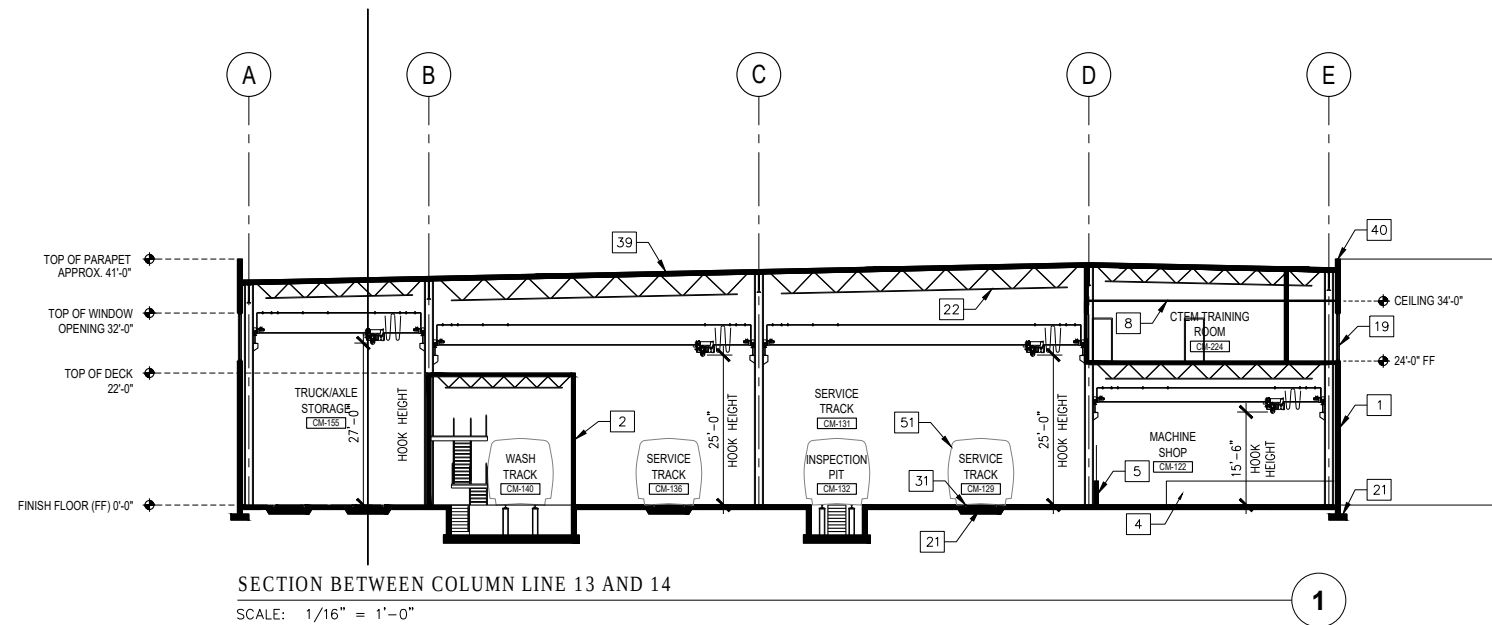

CONTRACT NO.
XXXXXXX



DESIGNED ASI 10/12/18 DRAWN RR 10/12/18 CHECKED MNG 10/12/18 APPROVED ASI 10/12/18	REFERENCE DRAWINGS		REVISIONS			WASHINGTON METROPOLITAN TRANSIT AUTHORITY DEPARTMENT OF TRANSIT INFRASTRUCTURE AND ENGINEERING SERVICES OFFICE OF MAJOR CAPITAL PROJECTS SUBMITTED _____ DATE _____ APPROVED _____ CHIEF ENGINEER _____ DATE _____	PENNSY DRIVE RAIL MAINTENANCE FACILITY BUILDING SECTIONS – 1 – CTRM/TRST BUILDING			SCALE 1/16" = 1'-0" DRAWING NO. A-301 SHEET NO. 10 of 24
	NUMBER	DESCRIPTION	DATE	BY	DESCRIPTION					



0 4' 8' 16' 32'

1/16"=1'-0"

DESIGNED ASI 10/12/18 DATE			REFERENCE DRAWINGS		REVISIONS			WASHINGTON METROPOLITAN TRANSIT AUTHORITY DEPARTMENT OF TRANSIT INFRASTRUCTURE AND ENGINEERING SERVICES OFFICE OF MAJOR CAPITAL PROJECTS SUBMITTED _____ DATE _____ APPROVED _____ DATE _____ CHIEF ENGINEER	PENNSY DRIVE RAIL MAINTENANCE FACILITY		
DRAWN RR 10/12/18 DATE			NUMBER	DESCRIPTION	DATE	BY	DESCRIPTION		BUILDING SECTIONS – 2 –		
CHECKED MNG 10/12/18 DATE									CTRM/TRST BUILDING ELEVATIONS		
APPROVED ASI 10/12/18 DATE									SCALE	DRAWING NO. ☐	SHEET NO.
									1/16" = 1'-0"	A-302	11 of 24

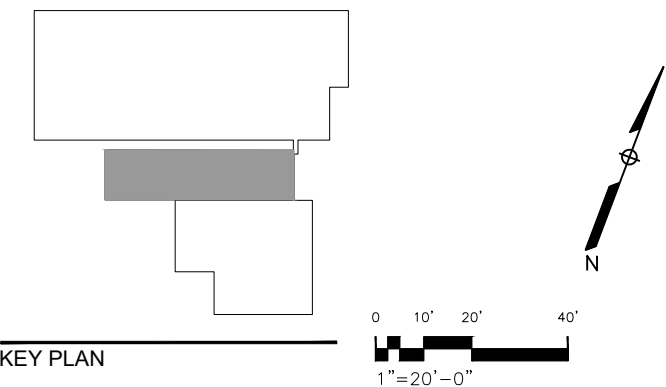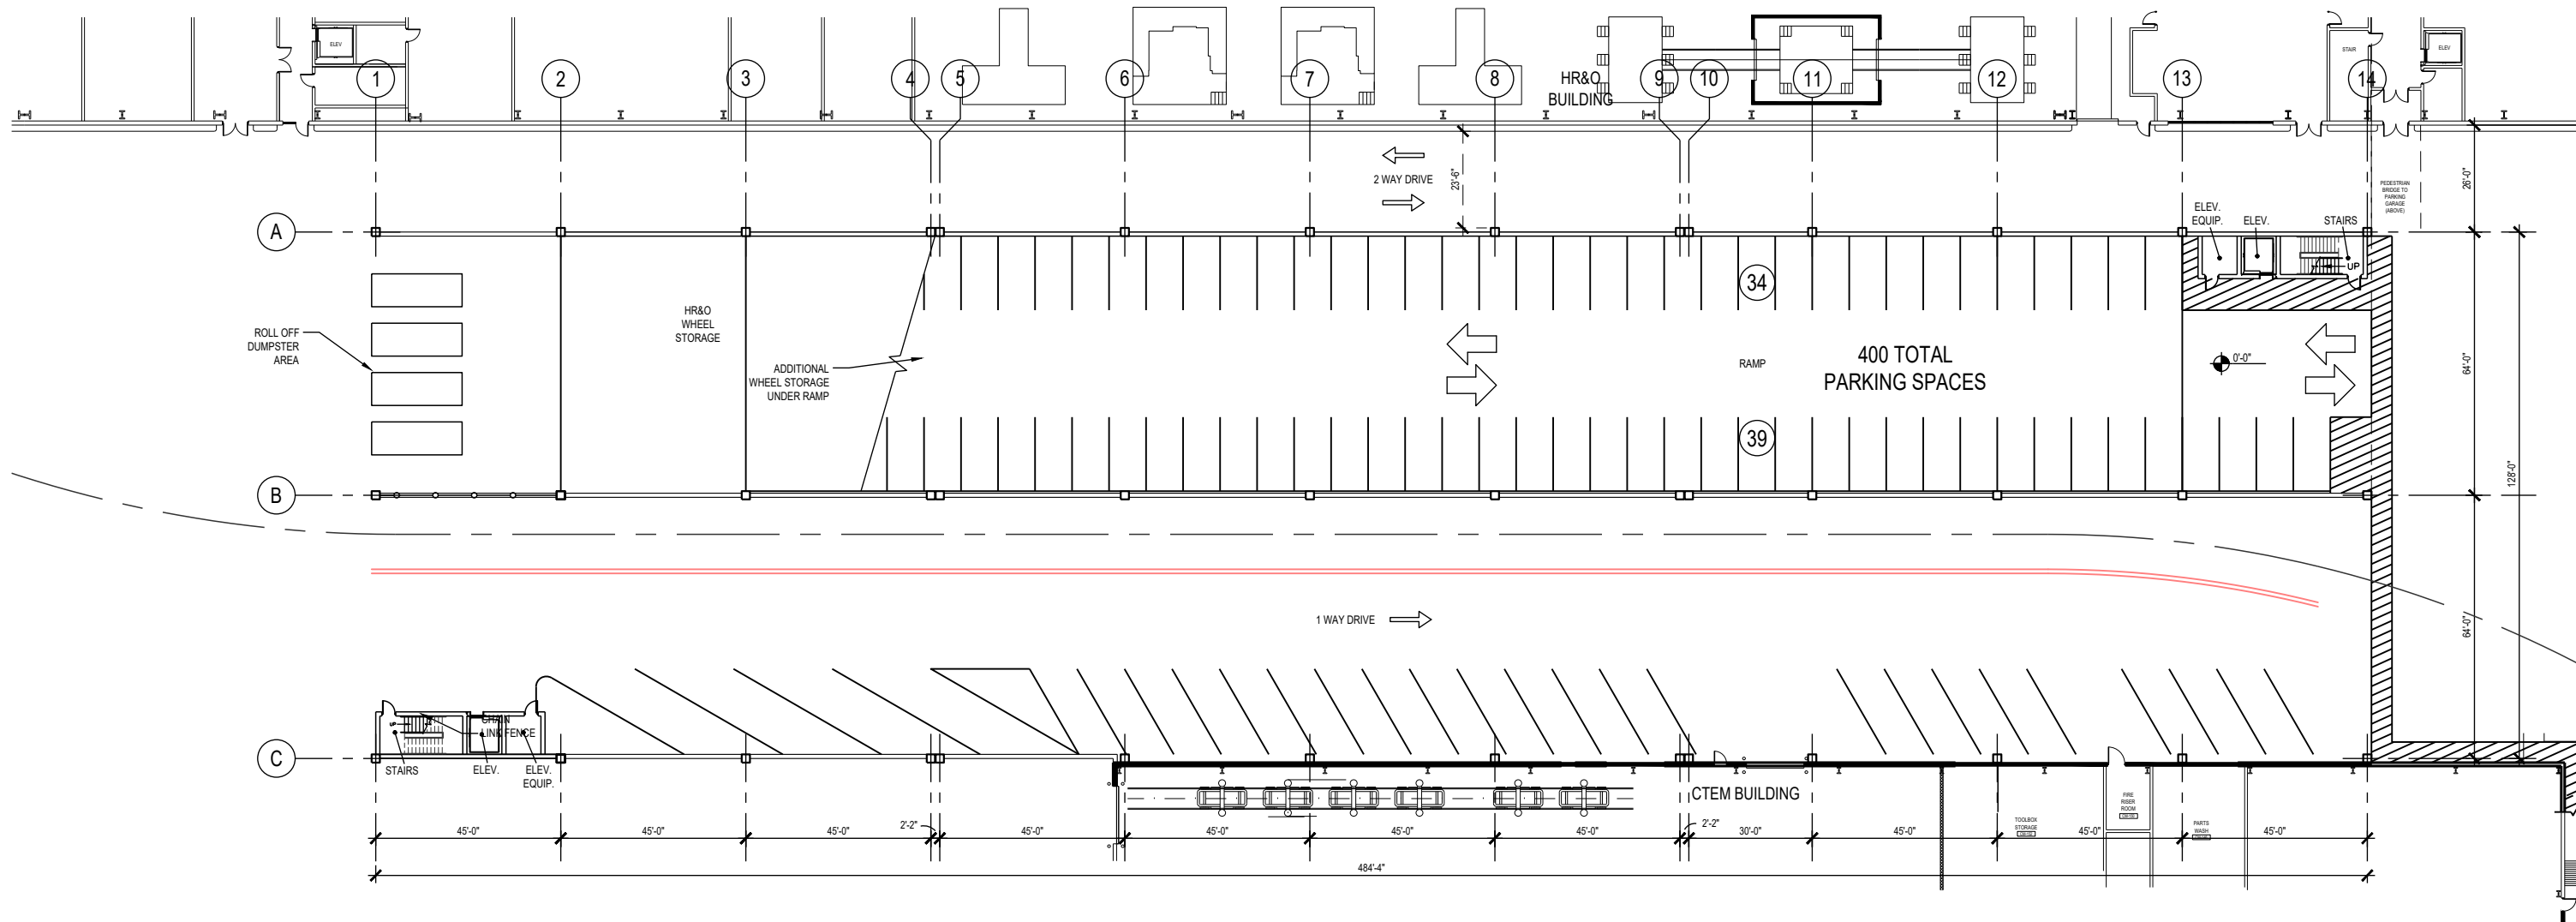

DESIGNED	ASI	10/12/18
		DATE
DRAWN	RR	10/12/18
		DATE
CHECKED	MNG	10/12/18
		DATE
APPROVED	***	10/12/18
		DATE

REFERENCE DRAWINGS	
NUMBER	DESCRIPTION

REVISIONS		
DATE	BY	DESCRIPTION

WASHINGTON METROPOLITAN TRANSIT AUTHORITY

DEPARTMENT OF TRANSIT INFRASTRUCTURE AND ENGINEERING SERVICES
OFFICE OF MAJOR CAPITAL PROJECTS

SUBMITTED _____ DATE _____

APPROVED _____
CHIEF ENGINEER DATE _____

PENNSY DRIVE RAIL MAINTENANCE FACILITY


Ground Level Plan - CTEM/TRST and HR&O
Parking Garage - Pennsy Drive

SCALE
1" = 20'-0"


DRAWING NO.
PG-A-101

SHEET NO.
12 of 24

CONTRACT NO.
XXXXXXX

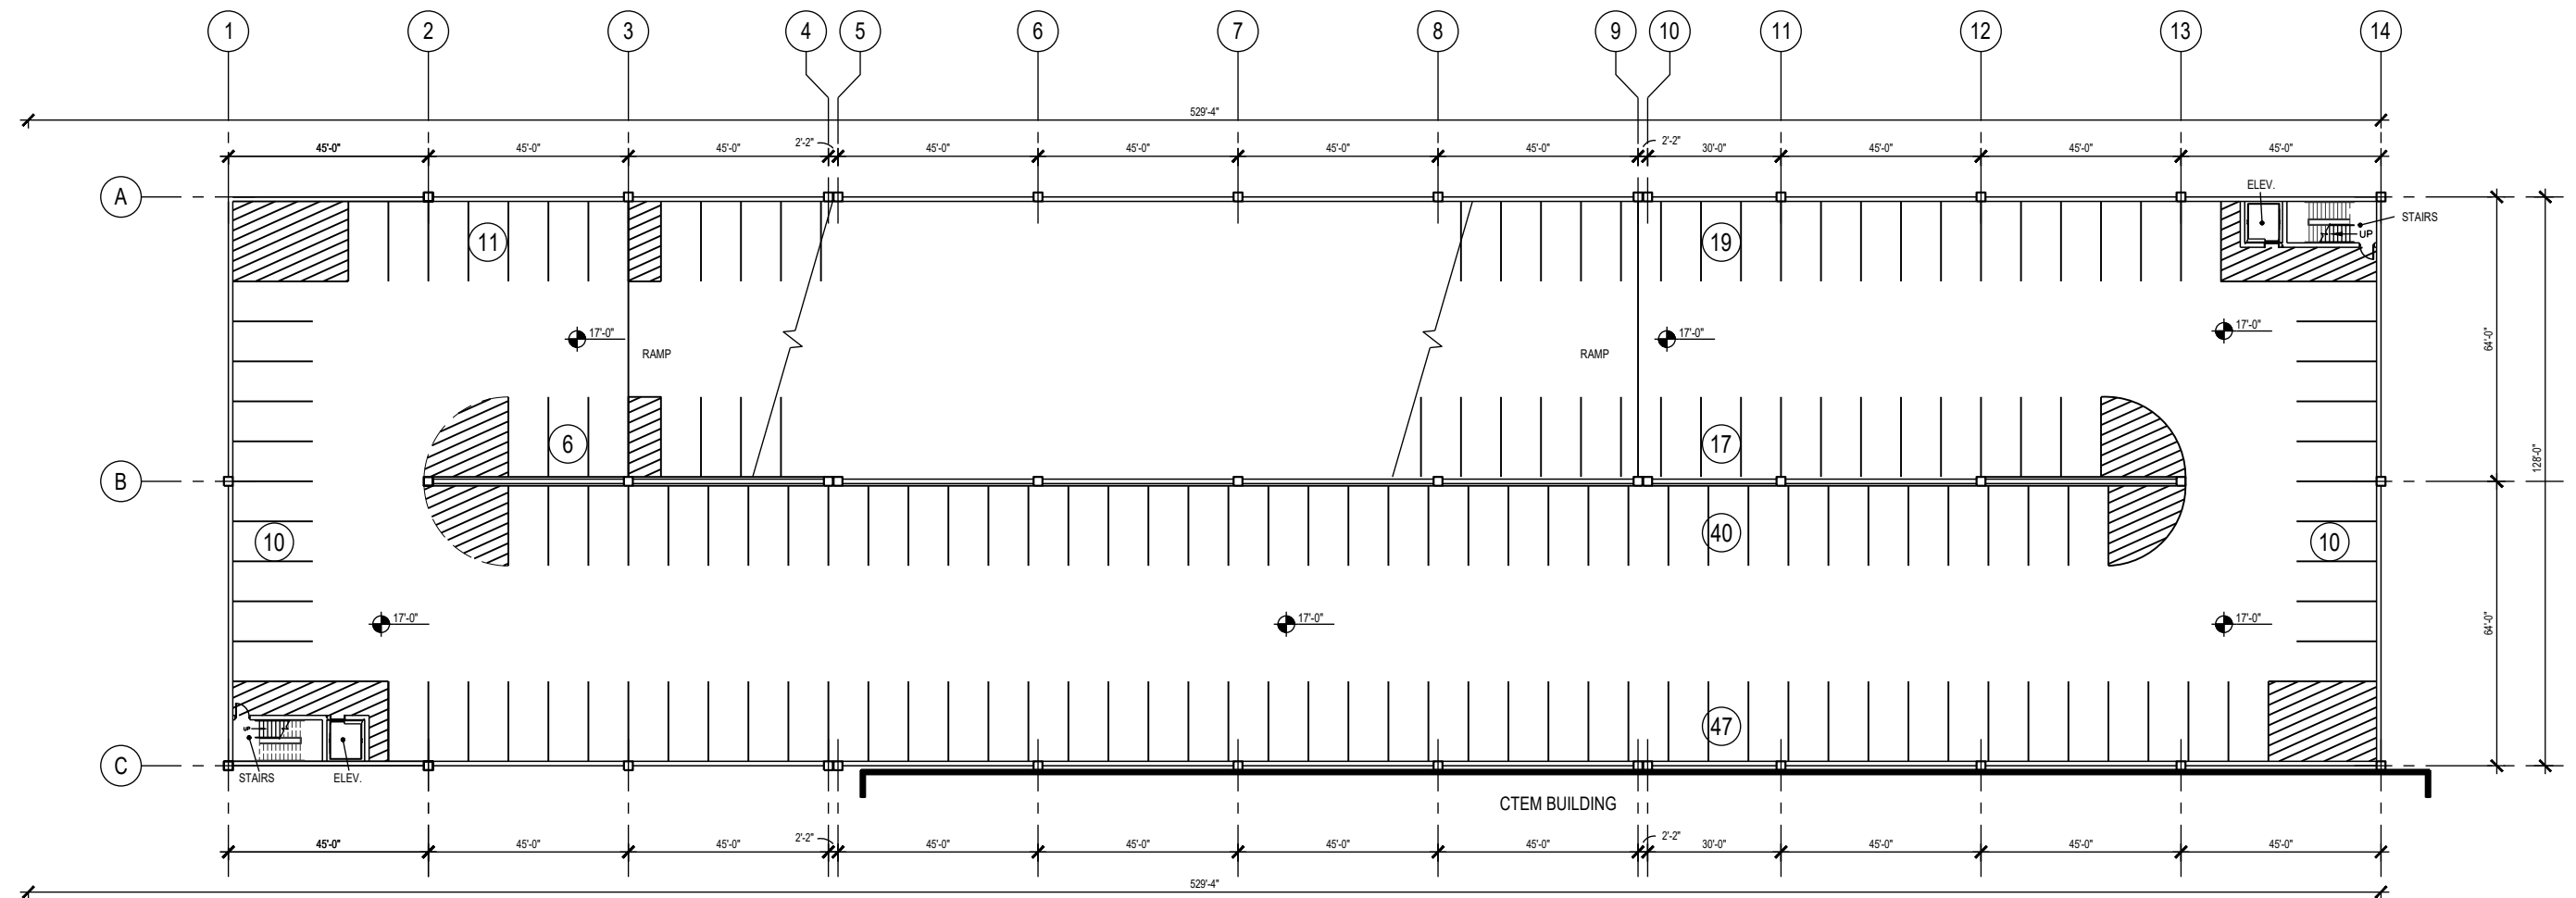

DESIGNEDASI10/12/18 DATE DRAWNRR10/12/18 DATE CHECKEDMNG10/12/18 DATE APPROVED***10/12/18 DATE			<table><thead><tr><th colspan="2">REFERENCE DRAWINGS</th><th colspan="2">REVISIONS</th></tr><tr><th>NUMBER</th><th>DESCRIPTION</th><th>DATE</th><th>BY</th><th>DESCRIPTION</th></tr></thead><tbody><tr><td> </td><td> </td><td> </td><td> </td><td> </td></tr><tr><td> </td><td> </td><td> </td><td> </td><td> </td></tr><tr><td> </td><td> </td><td> </td><td> </td><td> </td></tr><tr><td> </td><td> </td><td> </td><td> </td><td> </td></tr><tr><td> </td><td> </td><td> </td><td> </td><td> </td></tr></tbody></table>			REFERENCE DRAWINGS		REVISIONS		NUMBER	DESCRIPTION	DATE	BY	DESCRIPTION																										WASHINGTON METROPOLITAN TRANSIT AUTHORITY DEPARTMENT OF TRANSIT INFRASTRUCTURE AND ENGINEERING SERVICES OFFICE OF MAJOR CAPITAL PROJECTS SUBMITTEDDATEAPPROVEDCHIEF ENGINEERDATE		PENNSY DRIVE RAIL MAINTENANCE FACILITY Second Level Plan - CTEM/TRST and HR&O Parking Garage - Pennsy Drive SCALE1" = 20'-0"DRAWING NO.PG-A-102SHEET NO.13 of 24	
REFERENCE DRAWINGS		REVISIONS																																									
NUMBER	DESCRIPTION	DATE	BY	DESCRIPTION																																							

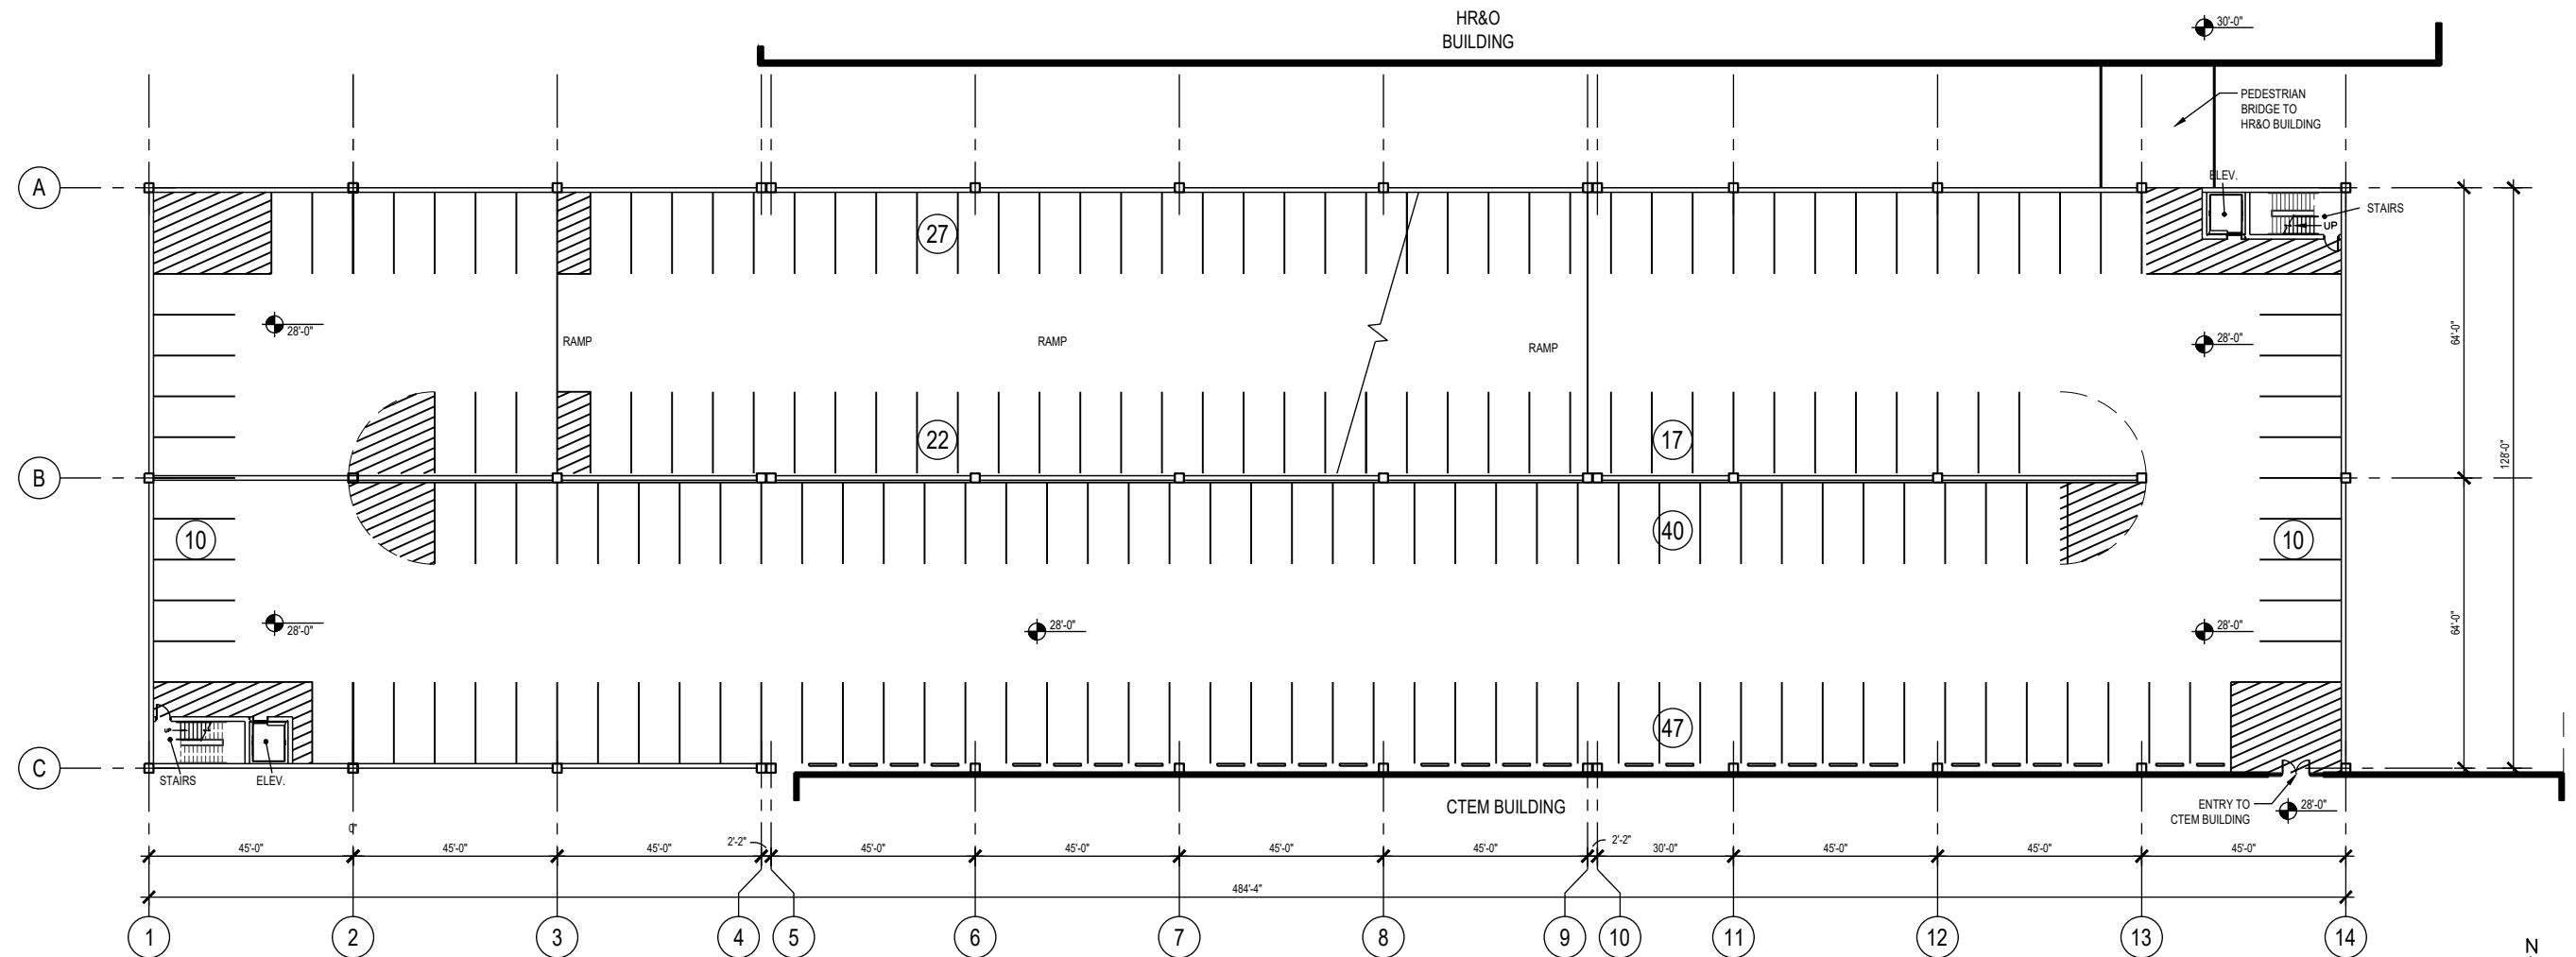

DESIGNED	ASI	10/12/18
		DATE
DRAWN	RR	10/12/18
		DATE
CHECKED	MNG	10/12/18
		DATE
APPROVED	***	10/12/18
		DATE

REFERENCE DRAWINGS	
NUMBER	DESCRIPTION

REVISIONS		
DATE	BY	DESCRIPTION



WASHINGTON METROPOLITAN TRANSIT AUTHORITY

DEPARTMENT OF TRANSIT INFRASTRUCTURE AND ENGINEERING SERVICES
OFFICE OF MAJOR CAPITAL PROJECTS

SUBMITTED _____ DATE _____

APPROVED _____
CHIEF ENGINEER

DATE _____

PENNSY DRIVE RAIL MAINTENANCE FACILITY

 

Third Level Plan - CTEM/TRST and HR&O
Parking Garage - Pennsy Drive

SCALE
1" = 20'-0"

DRAWING NO.
PG-A-103

SHEET NO.
14 of 24

CONTRACT NO.
XXXXXXX

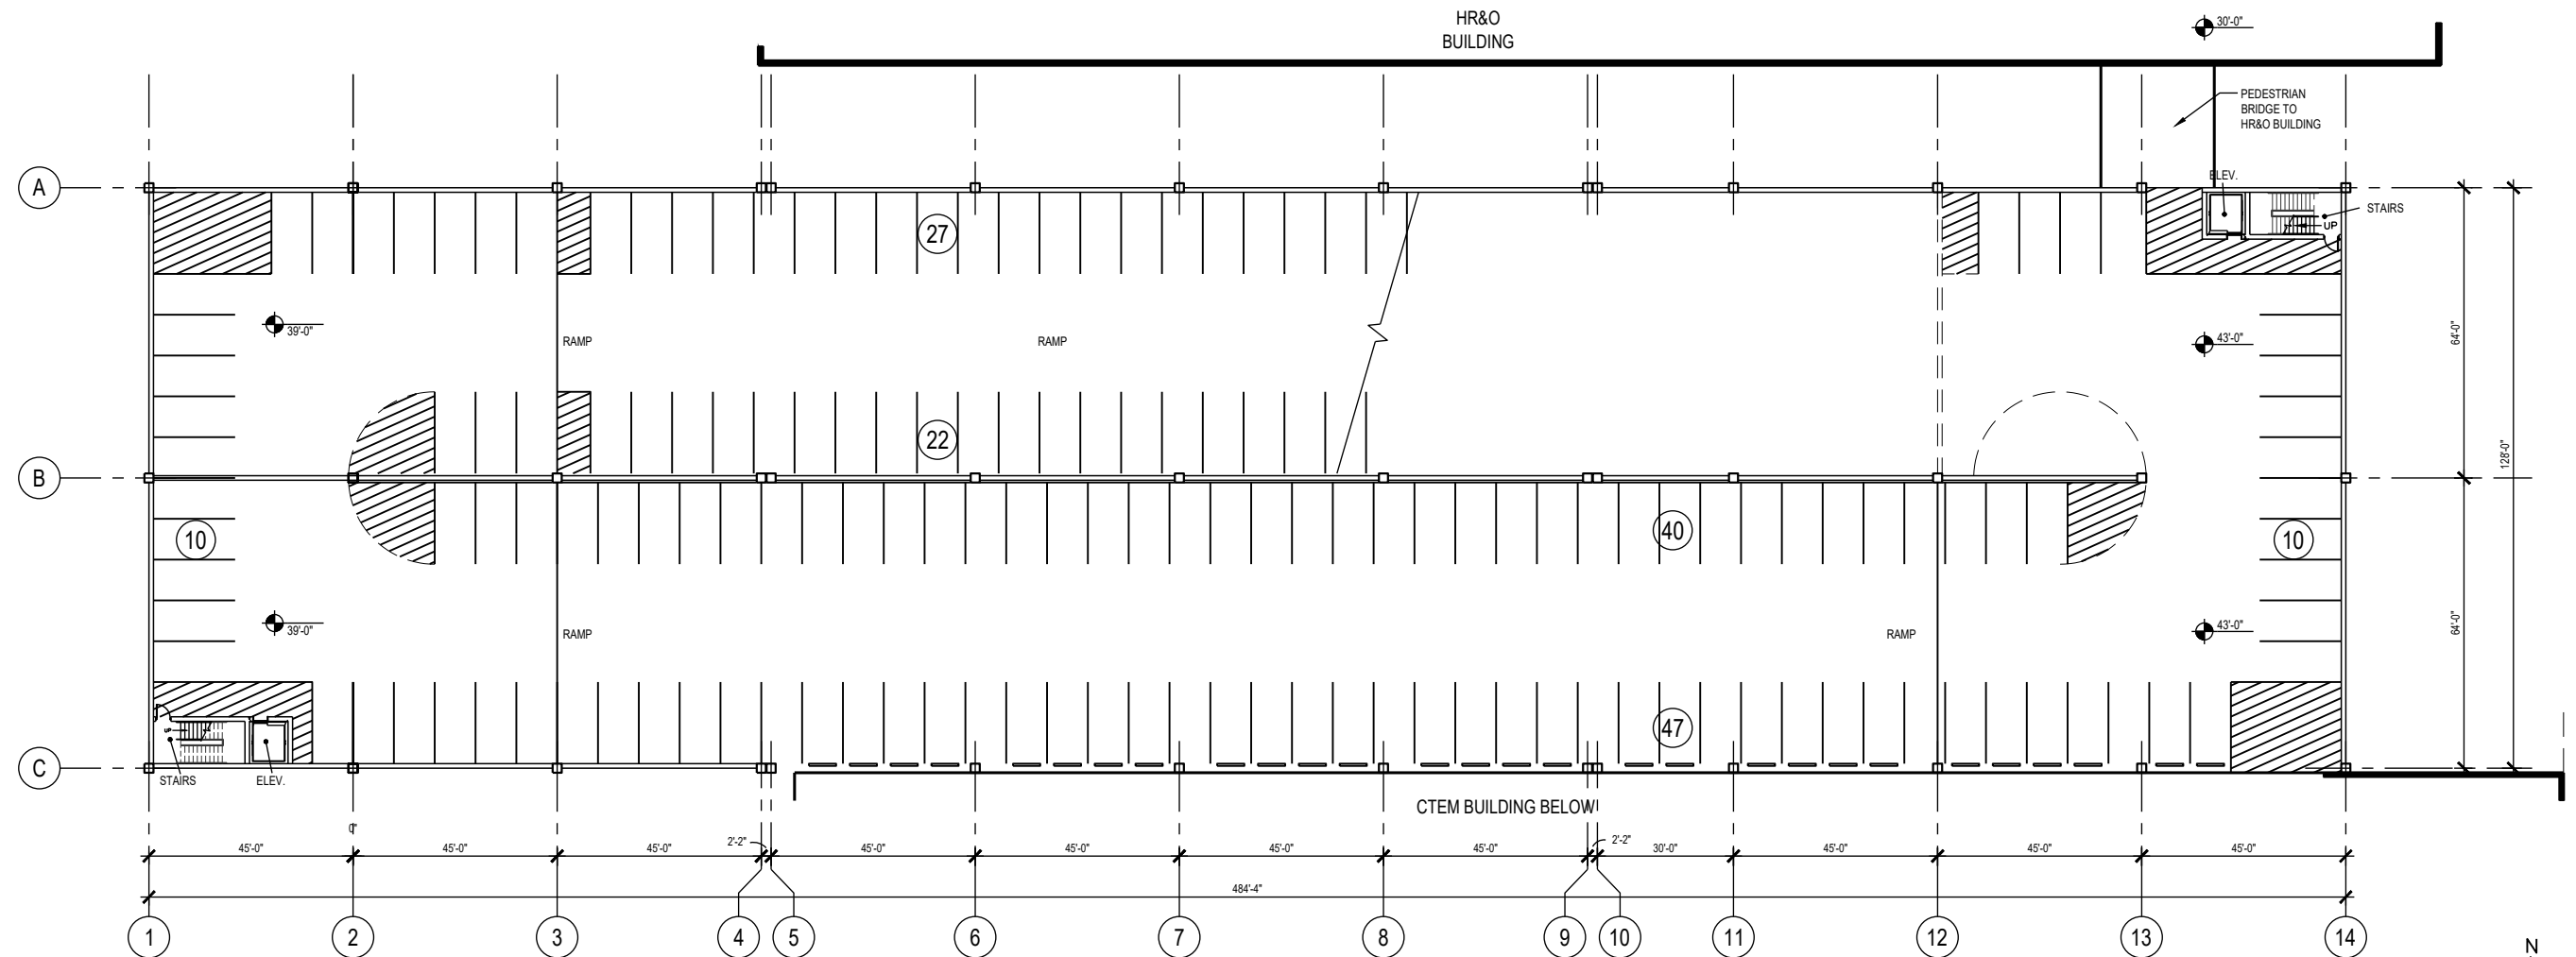

CONTRACT NO.
XXXXXXX

DESIGNED	ASI	10/12/18
		DATE
DRAWN	RR	10/12/18
		DATE
CHECKED	MNG	10/12/18
		DATE
APPROVED	***	10/12/18
		DATE

REFERENCE DRAWINGS	
NUMBER	DESCRIPTION

REVISIONS		
DATE	BY	DESCRIPTION

WASHINGTON METROPOLITAN TRANSIT AUTHORITY

DEPARTMENT OF TRANSIT INFRASTRUCTURE AND ENGINEERING SERVICES

OFFICE OF MAJOR CAPITAL PROJECTS

SUBMITTED

DATE

APPROVED

CHIEF ENGINEER

DATE

PENNSY DRIVE RAIL MAINTENANCE FACILITY

Fourth Level Plan - CTEM/TRST and HR&O

Parking Garage - Pennsy Drive

SCALE

 




1" = 20'-0"

DRAWING NO.

PG-A-104

SHEET NO.

15 of 24

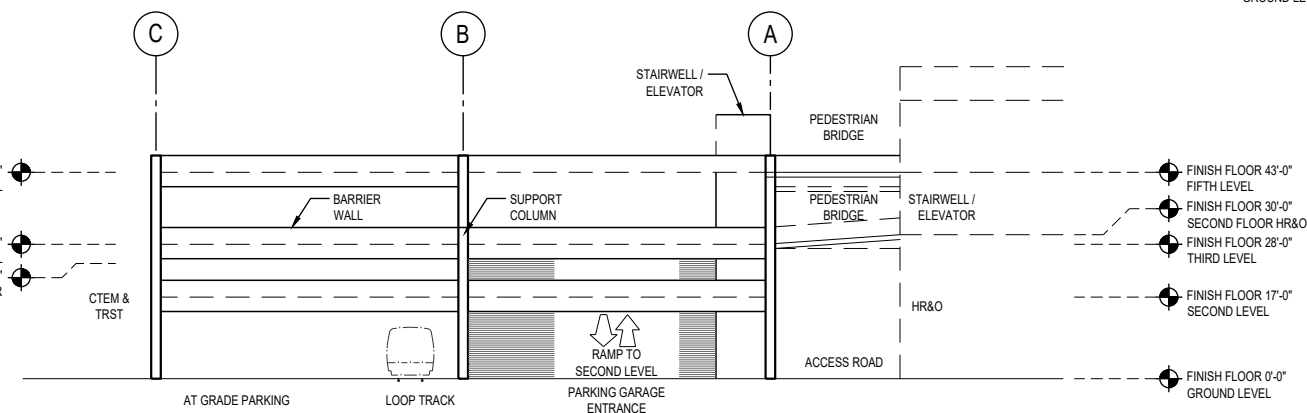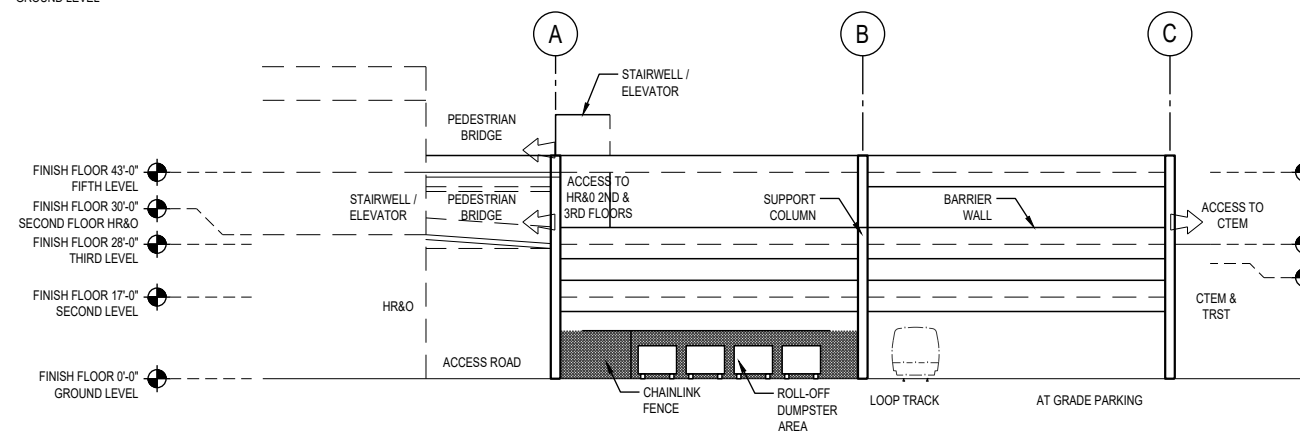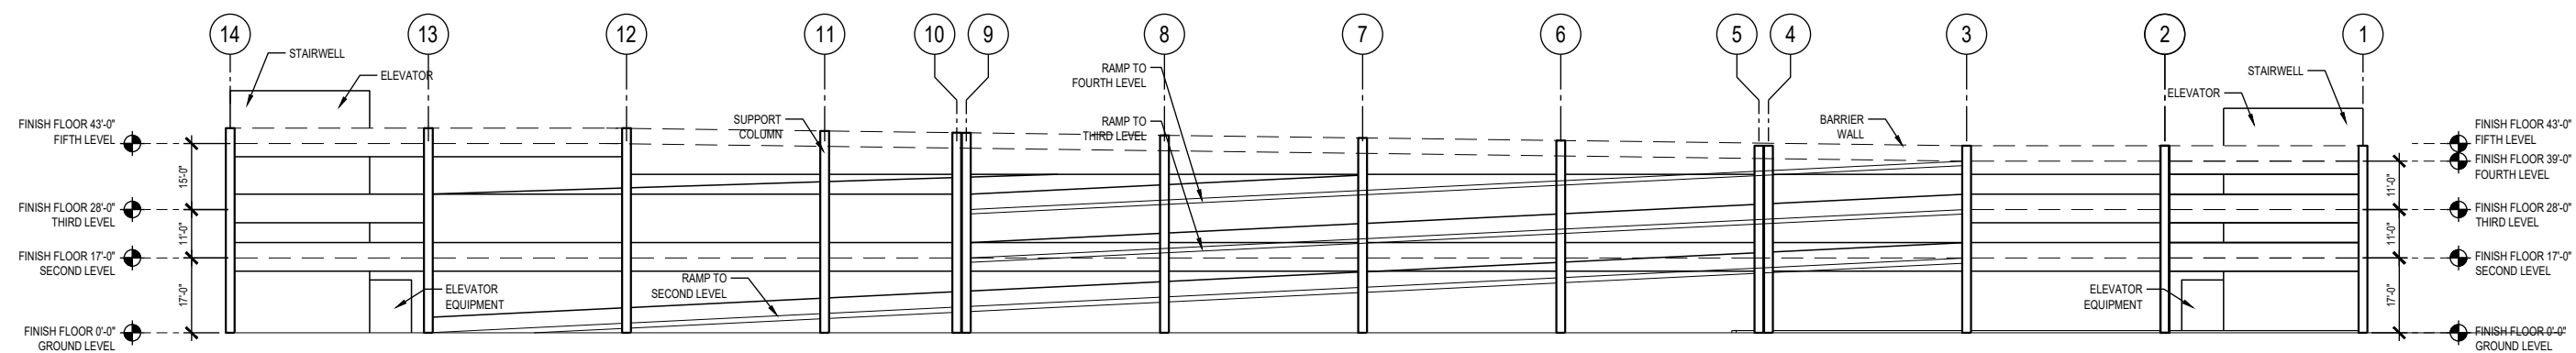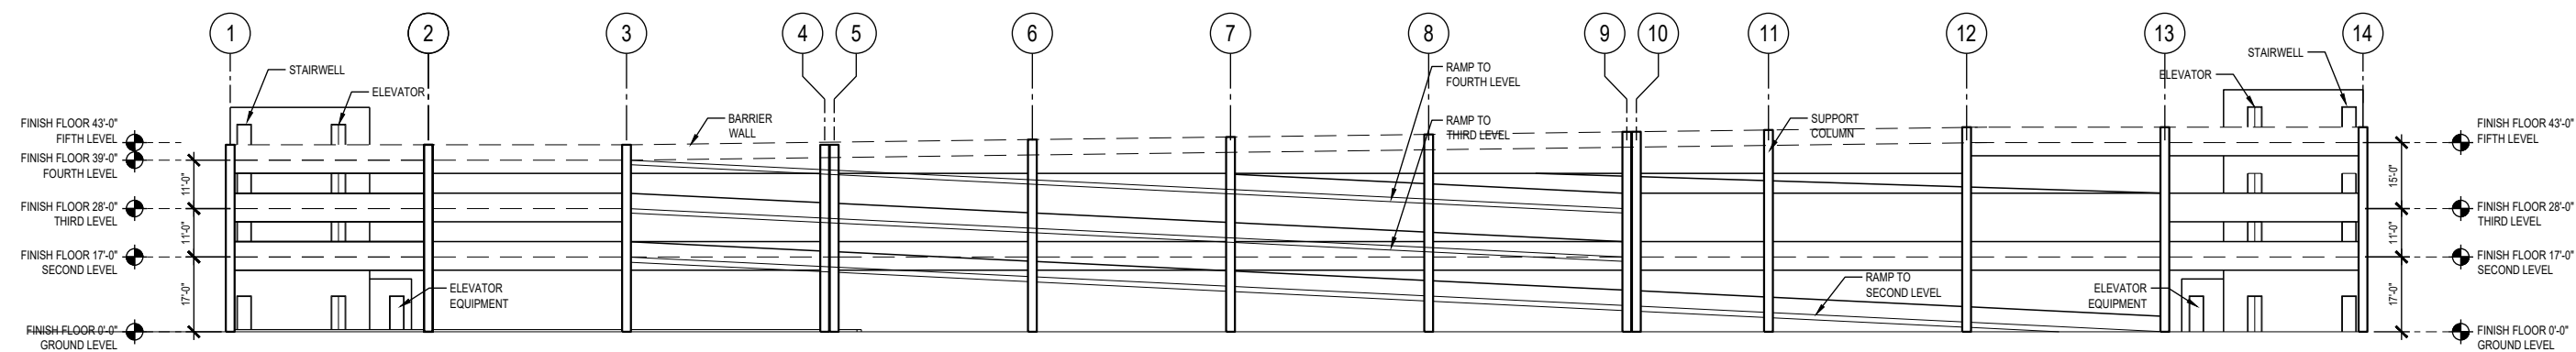

CONTRACT NO.
XXXXXXX

DESIGNED			REFERENCE DRAWINGS			REVISIONS		
AS	10/12/18	DATE	NUMBER	DESCRIPTION	DATE	BY	DESCRIPTION	
RR	10/12/18	DATE						
MNG	10/12/18	DATE						
***	10/12/18	DATE						

WASHINGTON METROPOLITAN TRANSIT AUTHORITY
DEPARTMENT OF TRANSIT INFRASTRUCTURE AND ENGINEERING SERVICES
OFFICE OF MAJOR CAPITAL PROJECTS

SUBMITTED _____ DATE _____


APPROVED _____ DATE _____
 CHIEF ENGINEER

PENNSY DRIVE RAIL MAINTENANCE FACILITY
Elevations - CTEM/TRST and HR&O
Parking Garage - Pennsy Drive


SCALE
1" = 20'-0"

DRAWING NO.
PG-A-201

SHEET NO.
16 of 24

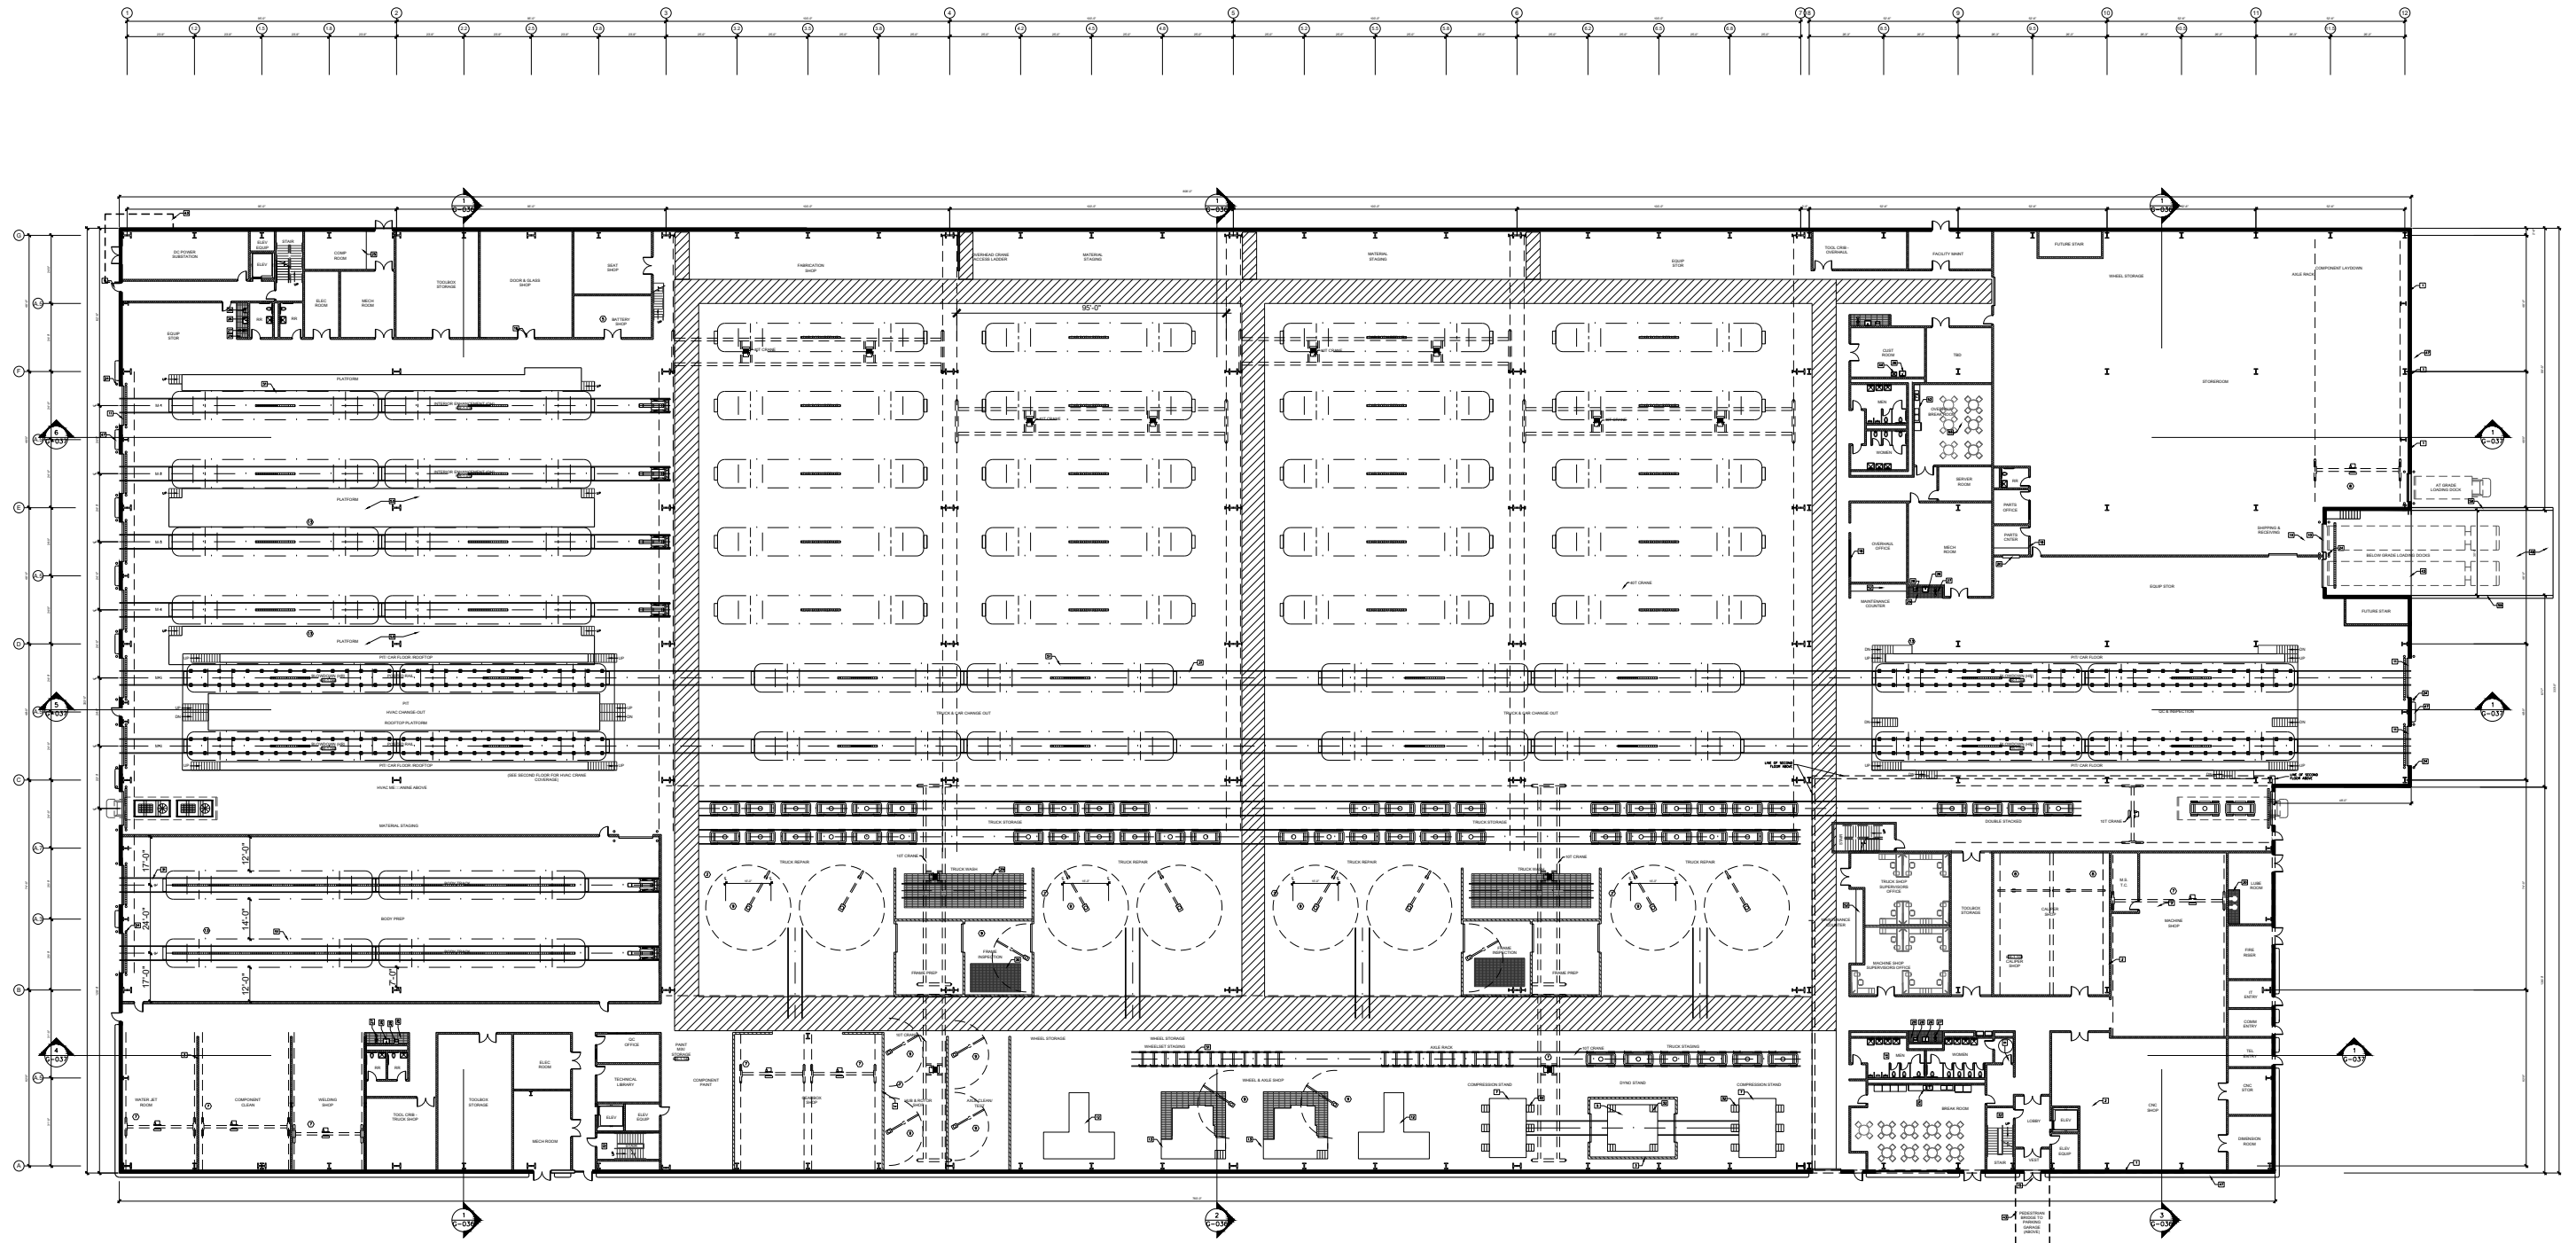

AREA 1	AREA 2	AREA 3	AREA 4
AREA 5	AREA 6	AREA 7	AREA 8
AREA 9	AREA 10	AREA 11	AREA 12
AREA 13	AREA 14	AREA 15	AREA 16

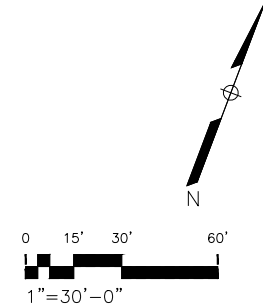

KEY PLAN			CONTRACT NO. XXXXXXX
WASHINGTON METROPOLITAN AREA TRANSIT AUTHORITY DEPARTMENT OF TRANSIT INFRASTRUCTURE AND ENGINEERING SERVICES OFFICE OF MAJOR CAPITAL PROJECTS			
HEAVY REPAIR & OVERHAUL FACILITY OVERALL ARCHITECTURE FIRST LEVEL PLAN PENNSY DRIVE			
SCALE 1" = 30'-0"	DRAWING NO. HR-A-100	SHEET NO. 017 of 24	

DESIGNED	ASI	9-21-2018
DRAWN	AH	9-21-2018
CHECKED	MNG	9-21-2018
APPROVED	ASI	9-21-2018



REFERENCE DRAWINGS	
NUMBER	DESCRIPTION

REVISIONS			
NUMBER	DESCRIPTION	DATE	BY





WSP USA
TWO GATEWAY CENTER
SUITE 1000
NEWARK, NEW JERSEY 07102

WASHINGTON METROPOLITAN AREA TRANSIT AUTHORITY DEPARTMENT OF TRANSIT INFRASTRUCTURE AND ENGINEERING SERVICES OFFICE OF MAJOR CAPITAL PROJECTS			
SUBMITTED	9/21/2018	APPROVED	
	DATE	CHIEF ENGINEER	DATE

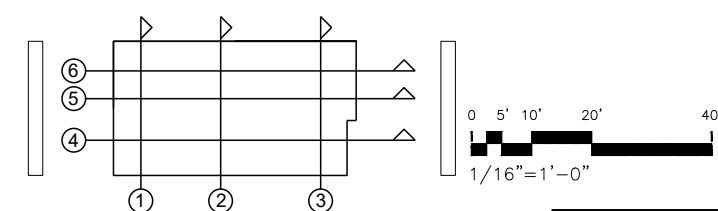
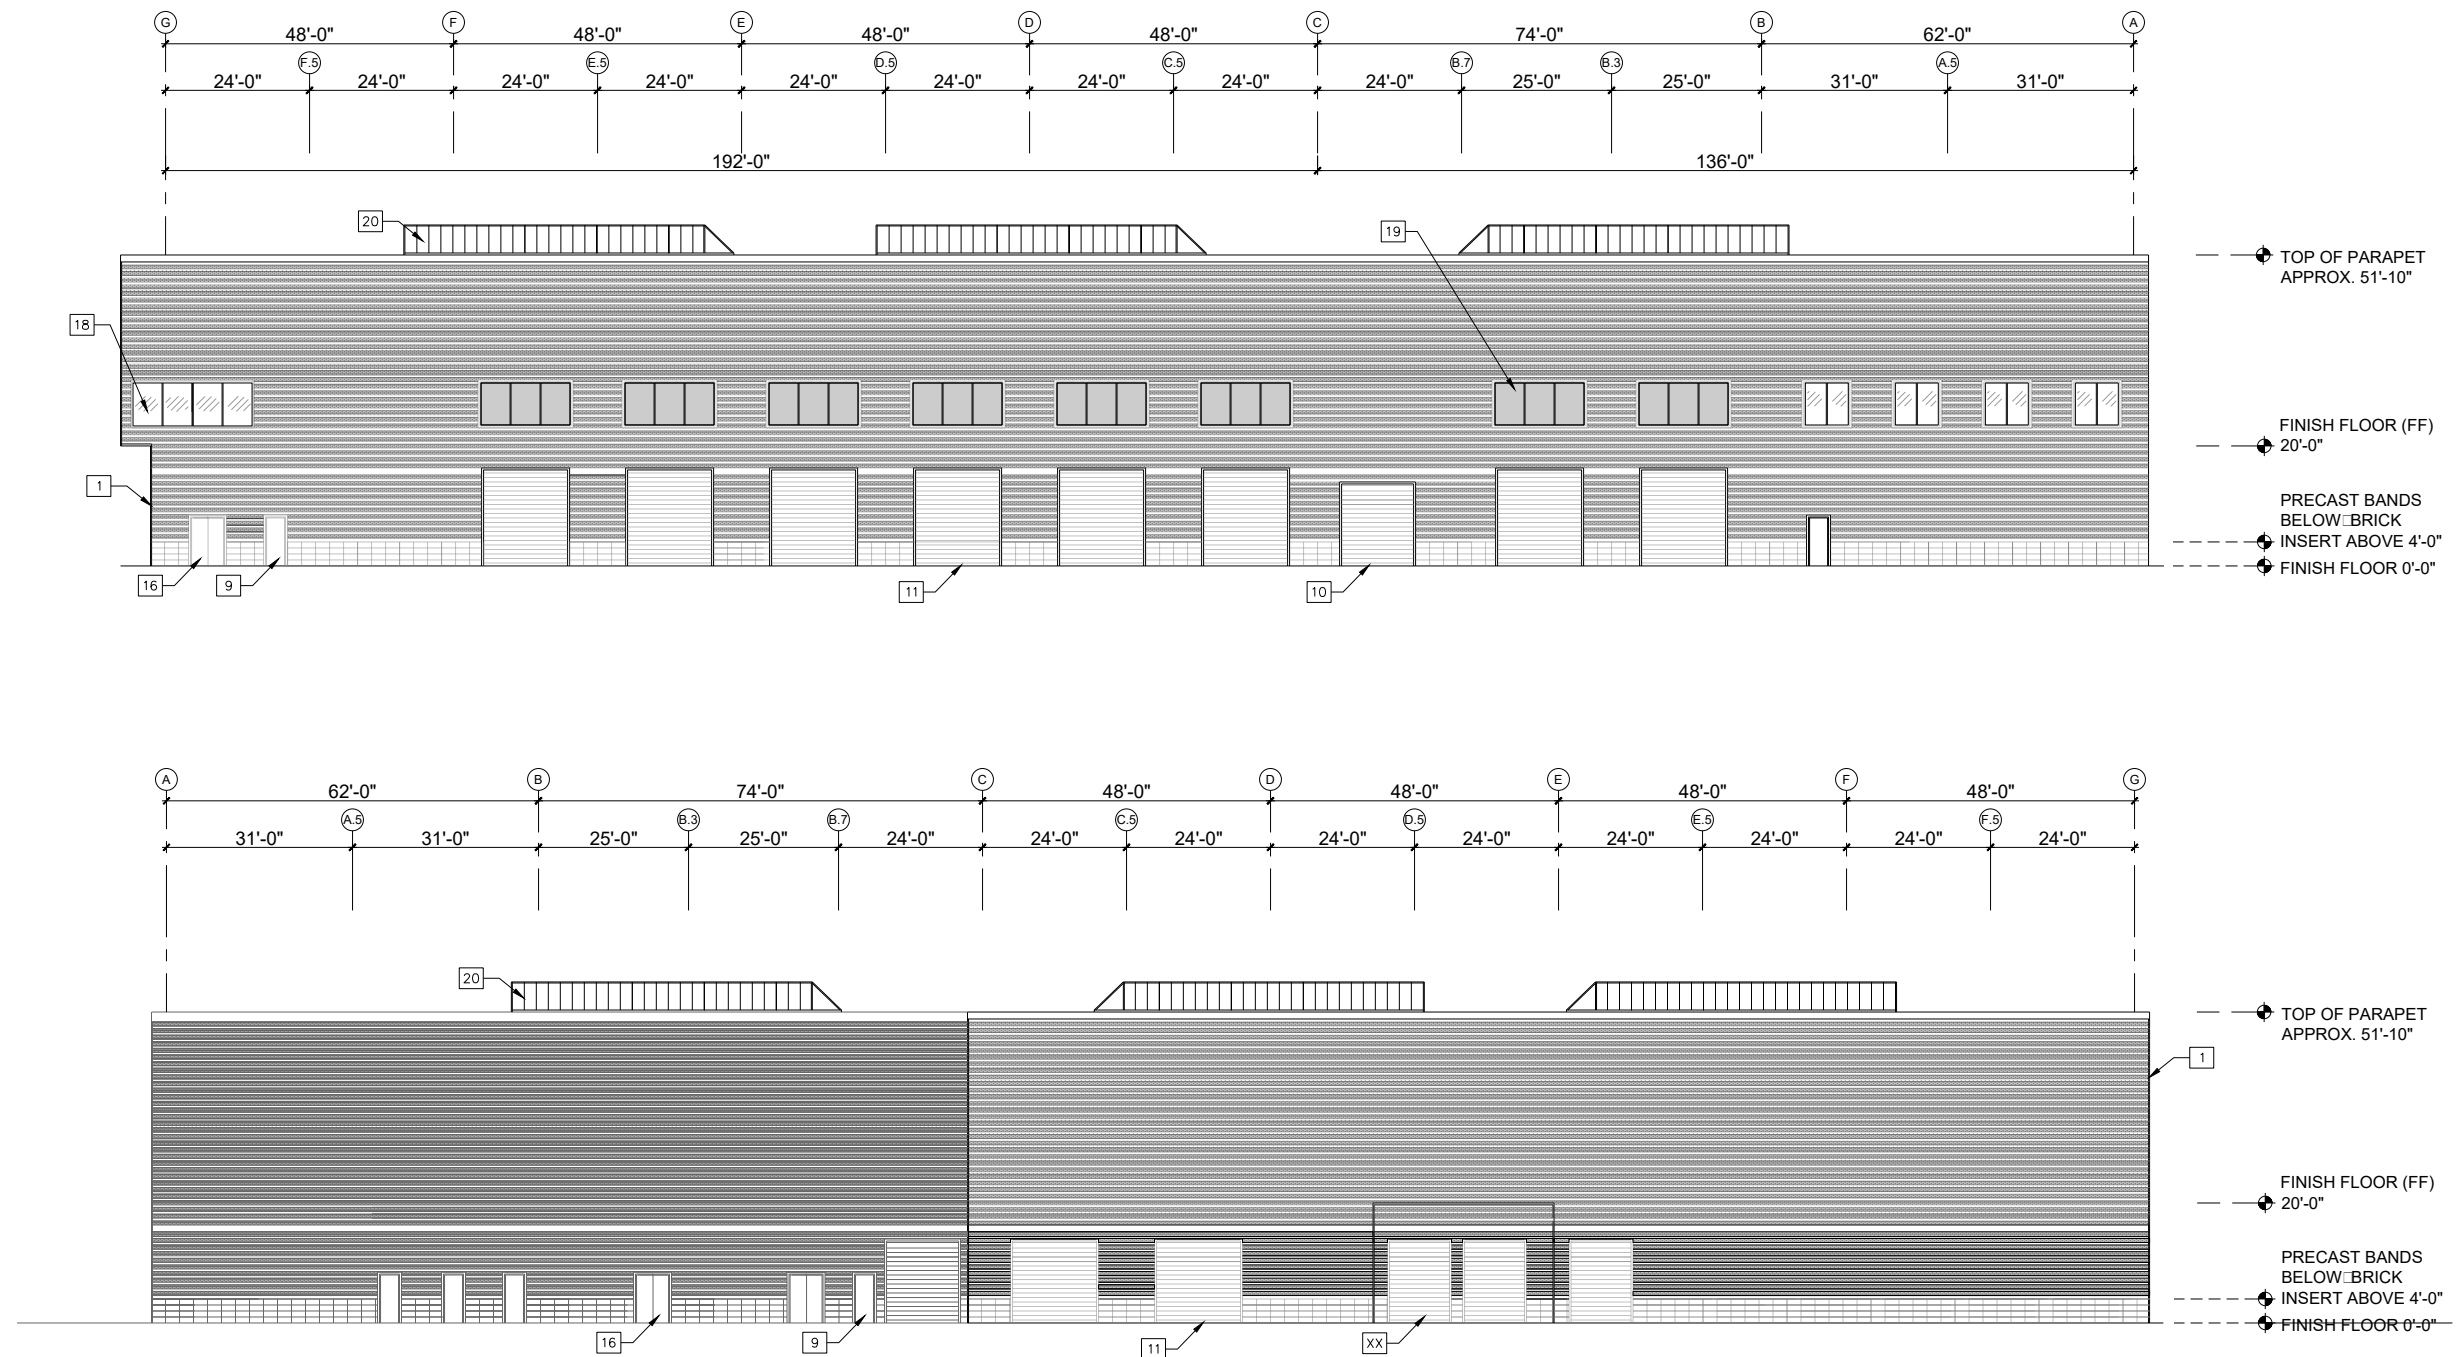


KEY PLAN		CONTRACT NO. XXXXXXX
HEAVY REPAIR & OVERHAUL FACILITY		
ARCHITECTURE - ELEVATIONS		
PENNSY DRIVE		
SCALE 1/16" = 1'-0"	DRAWING NO. HR-A-200	SHEET NO. 20 of 24

DESIGNED ASI 9-21-2018 DRAWN AH 9-21-2018 CHECKED MNG 9-21-2018 APPROVED ASI 9-21-2018	REFERENCE DRAWINGS		REVISIONS			 WSP USA TWO GATEWAY CENTER SUITE 1000 NEWARK, NEW JERSEY 07102	WASHINGTON METROPOLITAN AREA TRANSIT AUTHORITY			HEAVY REPAIR & OVERHAUL FACILITY			
	NUMBER	DESCRIPTION	DATE	BY	DESCRIPTION		DEPARTMENT OF TRANSIT INFRASTRUCTURE AND ENGINEERING SERVICES			ARCHITECTURE - ELEVATIONS			
							OFFICE OF MAJOR CAPITAL PROJECTS			PENNSY DRIVE			
							SUBMITTED	9/21/2018	APPROVED				
							DATE	DATE	CHIEF ENGINEER	DATE			

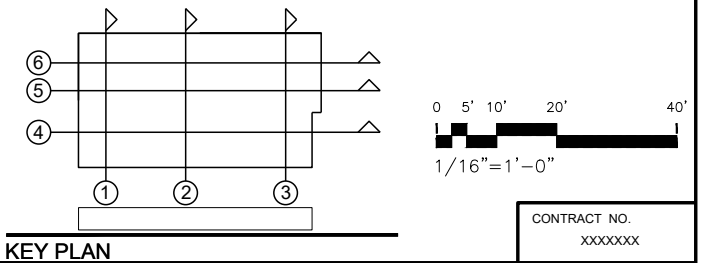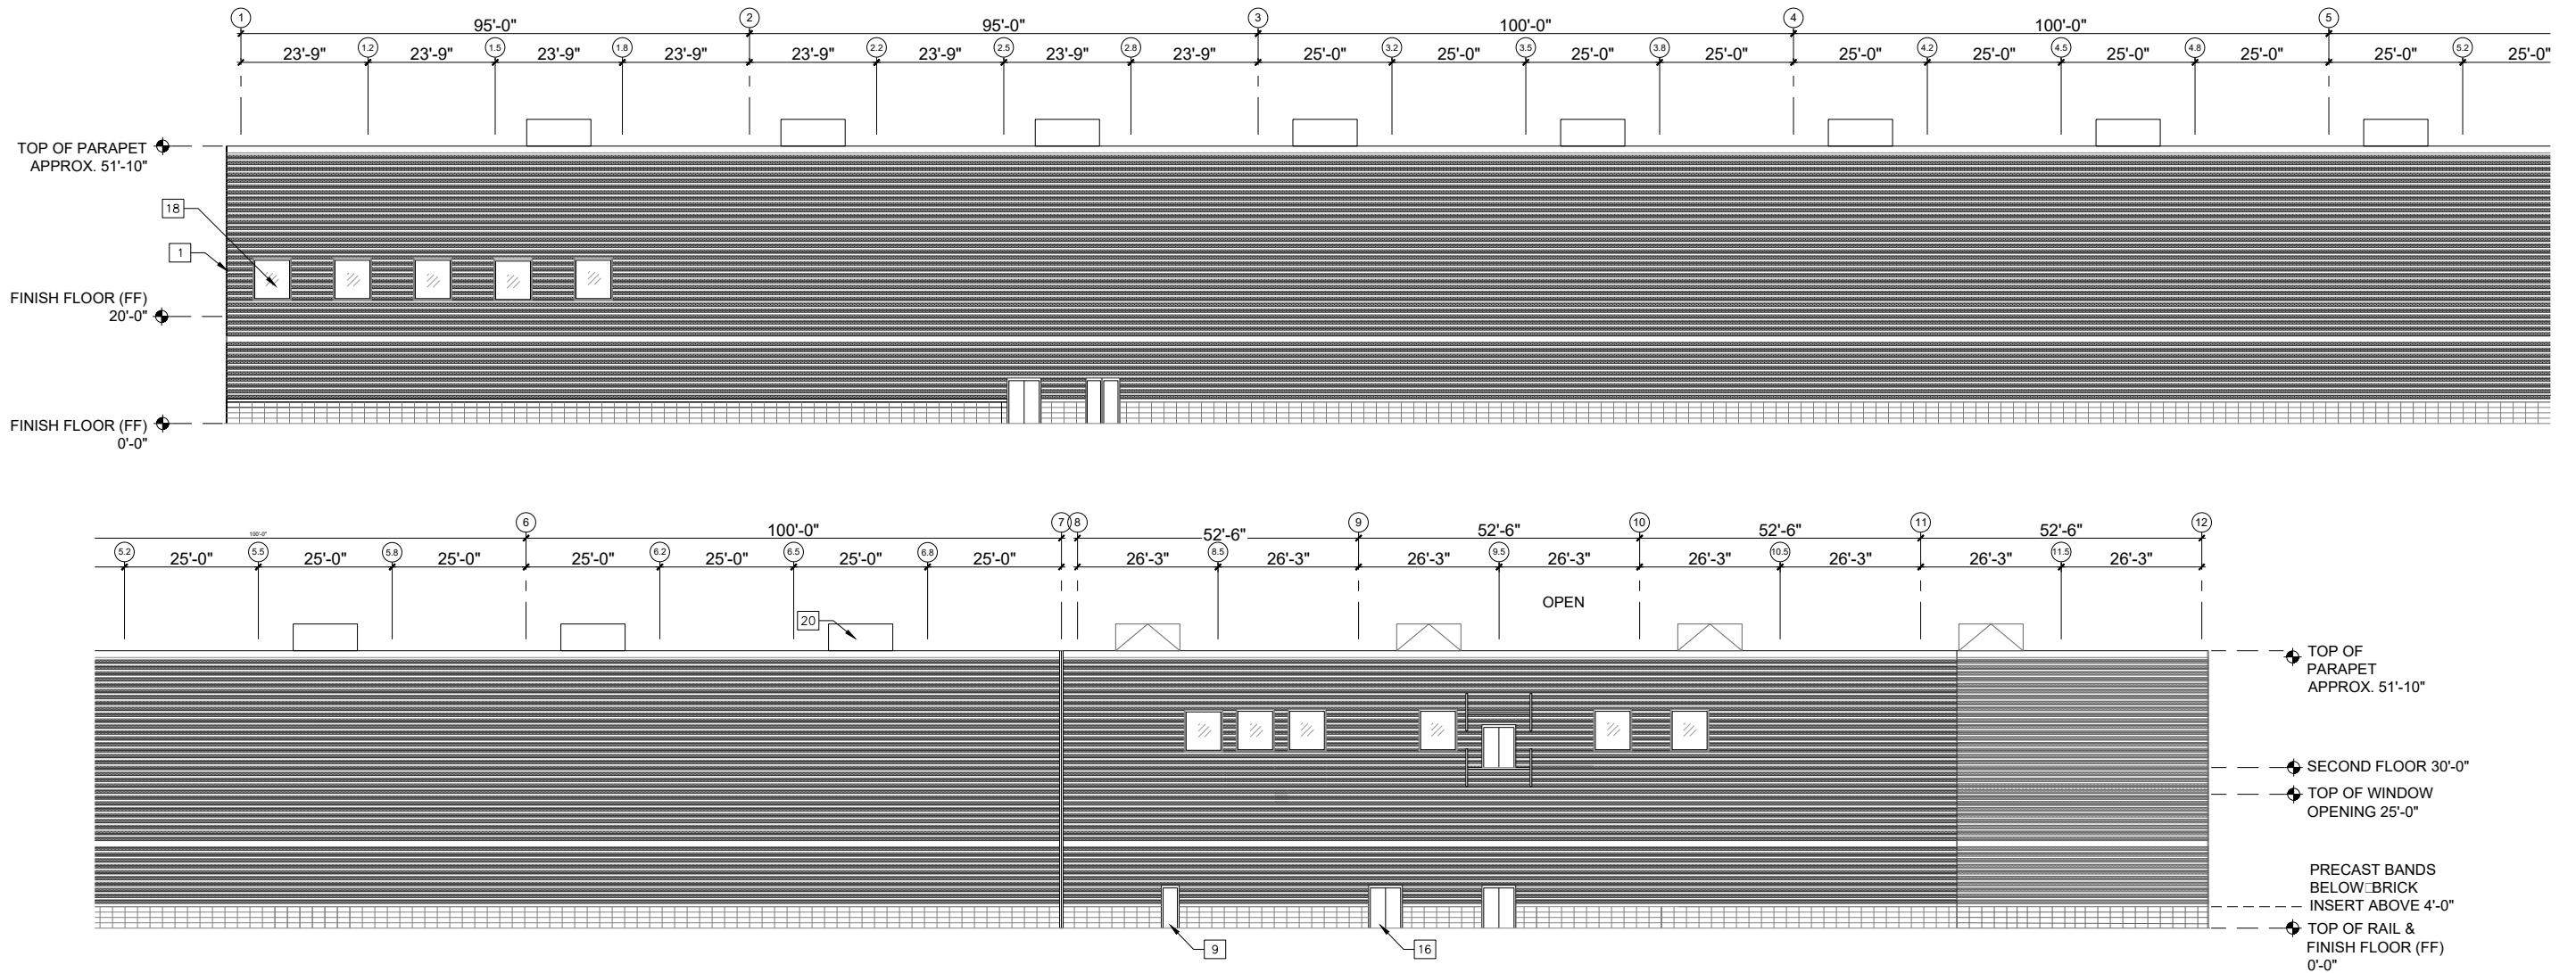


DESIGNED DRAWN CHECKED APPROVED	ASI	9-21-2018	REFERENCE DRAWINGS		REVISIONS			 WSP USA INC. TWO GATEWAY CENTER SUITE 1000 NEWARK, NEW JERSEY 07102	WASHINGTON METROPOLITAN AREA TRANSIT AUTHORITY DEPARTMENT OF TRANSIT INFRASTRUCTURE AND ENGINEERING SERVICES OFFICE OF MAJOR CAPITAL PROJECTS			HEAVY REPAIR & OVERHAUL FACILITY ARCHITECTURE ELEVATIONS PENNSY DRIVE								
		DATE	NUMBER	DESCRIPTION	DATE	BY	DESCRIPTION													
	AH	9-21-2018																		
		DATE																		
	MNG	9-21-2018																		
		DATE																		
	ASI	9-21-2018																		
	DATE									SUBMITTED		9/21/2018	APPROVED	SCALE		DRAWING NO.		SHEET NO.		
										DATE		DATE	CHIEF ENGINEER	DATE	1/16" = 1'-0"		HR-A-201		21 of 024	

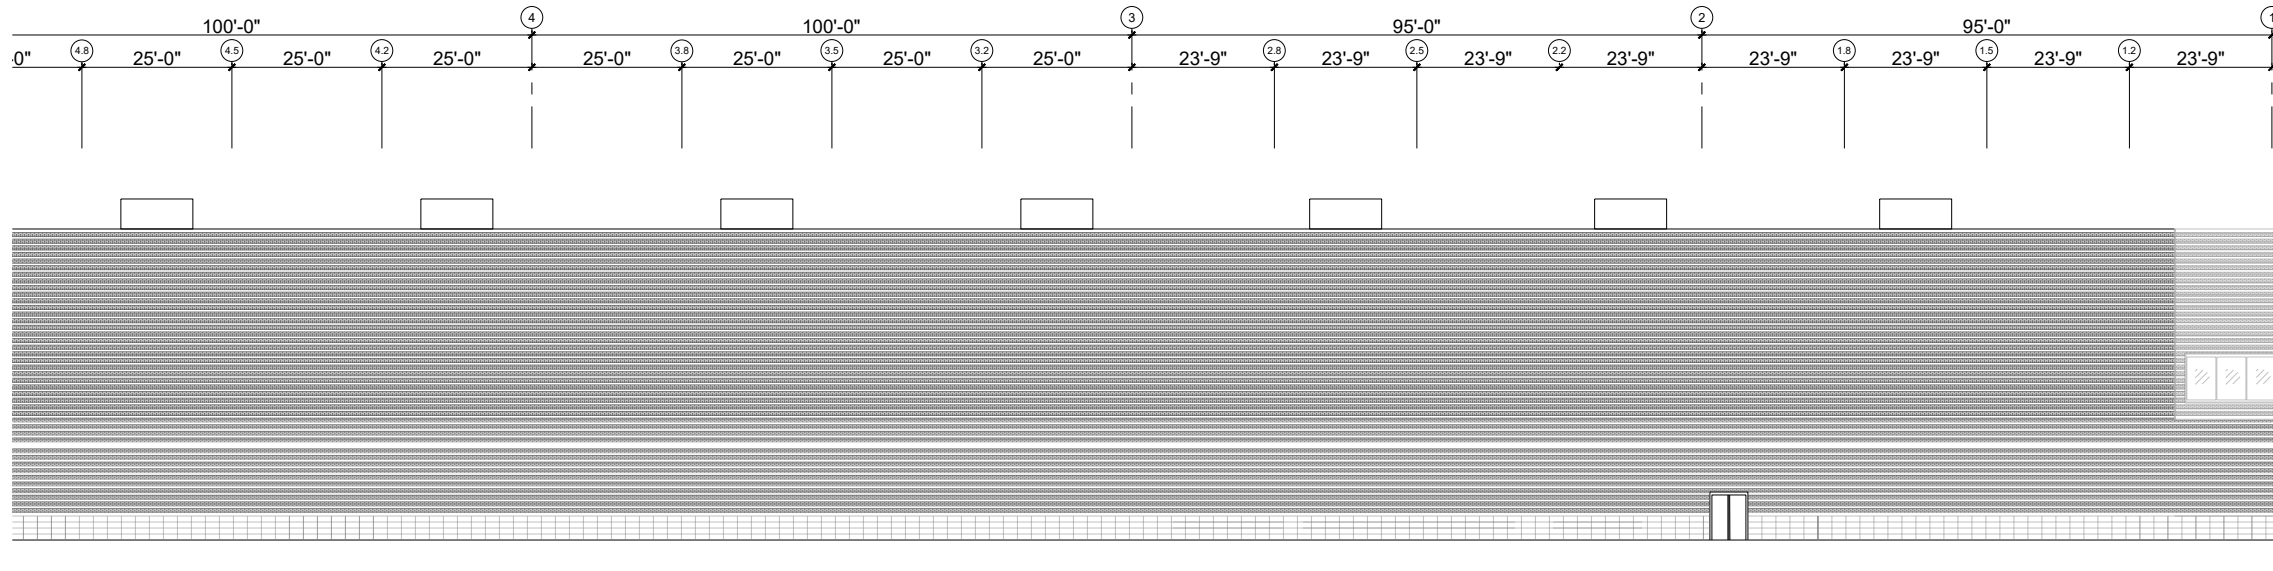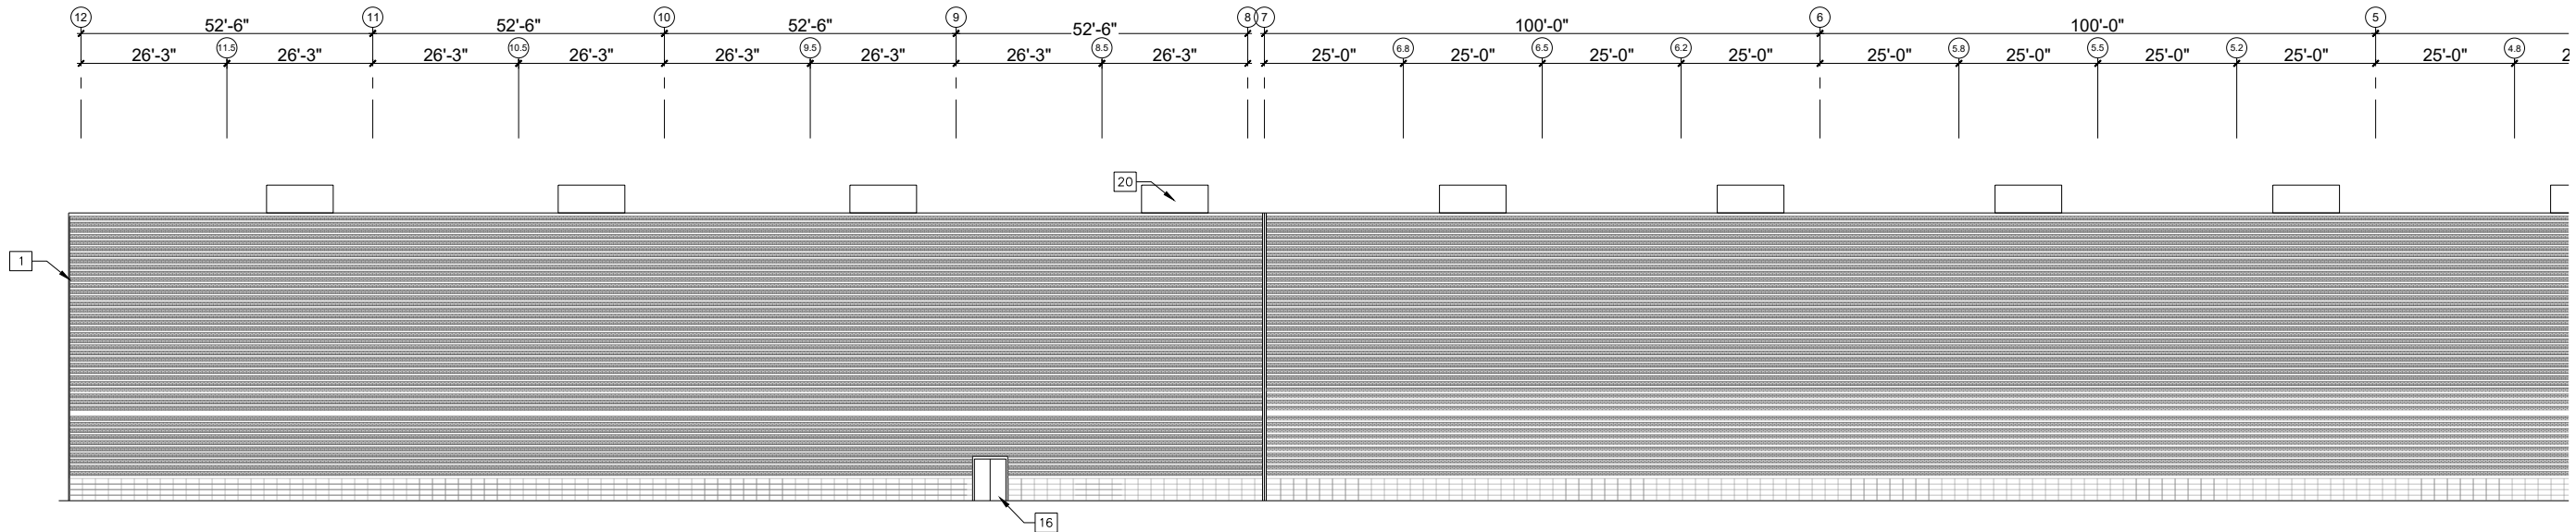

TOP OF PARAPET
APPROX. 51'-10"

FINISH FLOOR (FF)
20'-0"




FINISH FLOOR (FF)
0'-0"

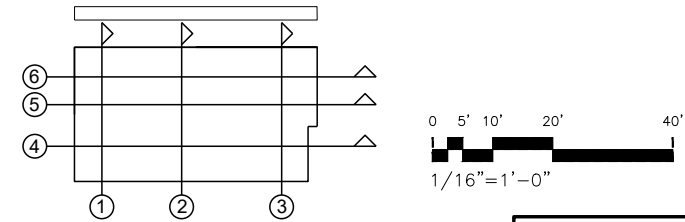

KEY PLAN

CONTRACT NO.
XXXXXXX

DESIGNED — ASI — DATE 9-21-2018	REFERENCE DRAWINGS		REVISIONS			 WSP USA TWO GATEWAY CENTER SUITE 1000 NEWARK, NEW JERSEY 07102	WASHINGTON METROPOLITAN AREA TRANSIT AUTHORITY DEPARTMENT OF TRANSIT INFRASTRUCTURE AND ENGINEERING SERVICES OFFICE OF MAJOR CAPITAL PROJECTS	HEAVY REPAIR & OVERHAUL FACILITY		
	DRAWN — AH — DATE 9-21-2018	NUMBER	DESCRIPTION	DATE	BY			ARCHITECTURE ELEVATIONS		
	CHECKED — MNG — DATE 9-21-2018							PENNSY DRIVE		
	APPROVED — ASI — DATE 9-21-2018							SCALE 1/16" = 1'-0"	DRAWING NO. HR-A-202	SHEET NO. 22 of 24

 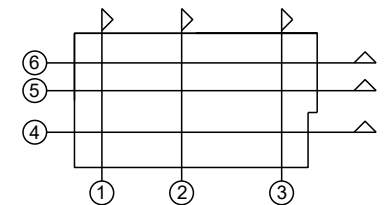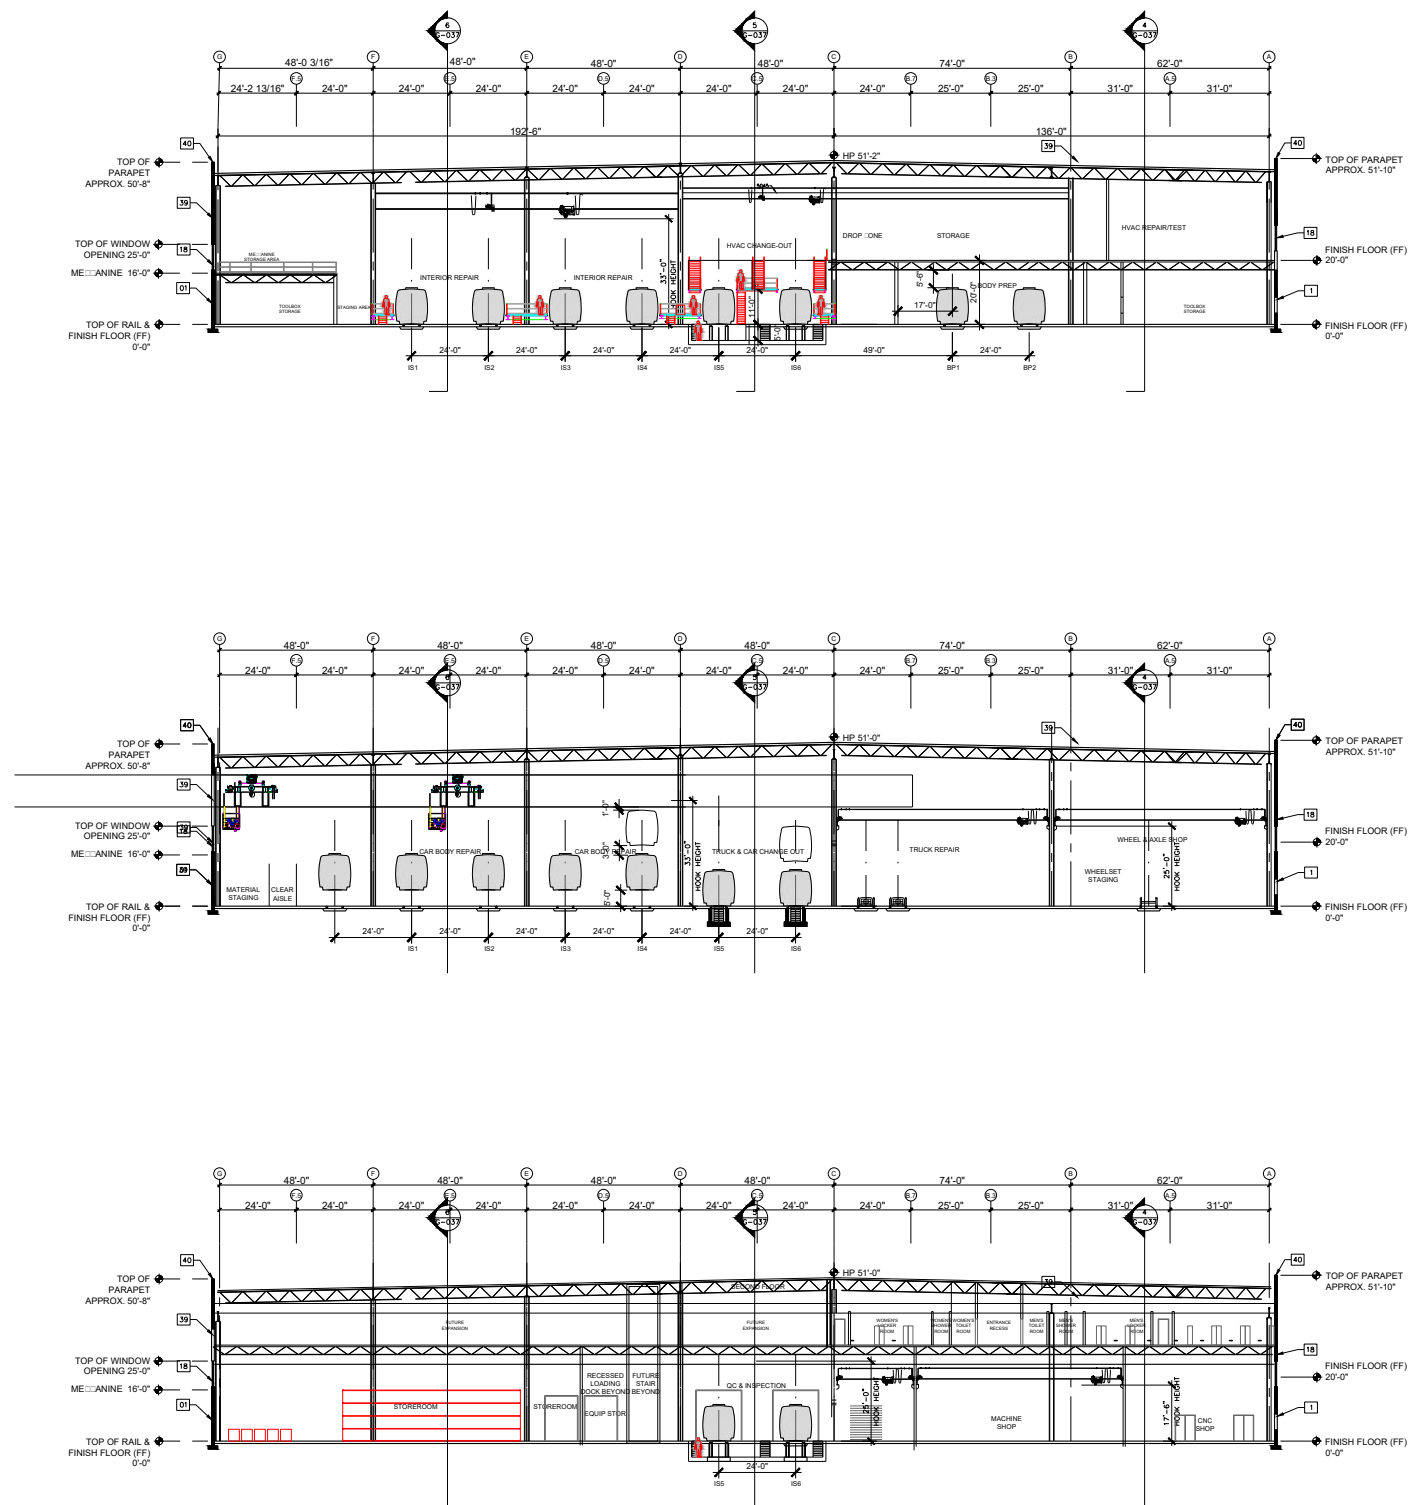

CONTRACT NO.
XXXXXXX

DESIGNED	ASI	9-21-2018
		DATE
DRAWN	AH	9-21-2018
		DATE
CHECKED	MNG	9-21-2018
		DATE
APPROVED	ASI	9-21-2018
		DATE

REFERENCE DRAWINGS	
NUMBER	DESCRIPTION

REVISIONS		
DATE	BY	DESCRIPTION



WASHINGTON METROPOLITAN AREA TRANSIT AUTHORITY
DEPARTMENT OF TRANSIT INFRASTRUCTURE AND ENGINEERING SERVICES
OFFICE OF MAJOR CAPITAL PROJECTS

SUBMITTED _____ 9/21/2018 _____
DATE DATE DATE

APPROVED _____
CHIEF ENGINEER DATE




KEY PLAN

HEAVY REPAIR & OVERHAUL FACILITY
ARCHITECTURE - CROSS SECTIONS
PENNSY DRIVE

SCALE
1" = 30'-0"

DRAWING NO.
HR-A-300

SHEET NO.
23 of 24

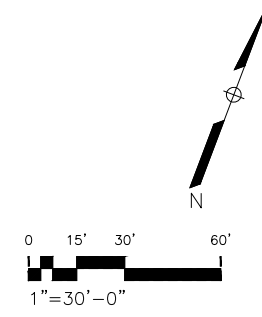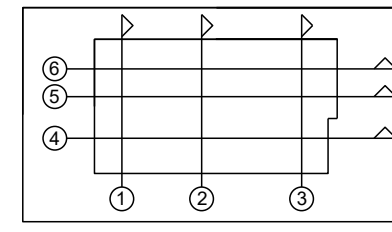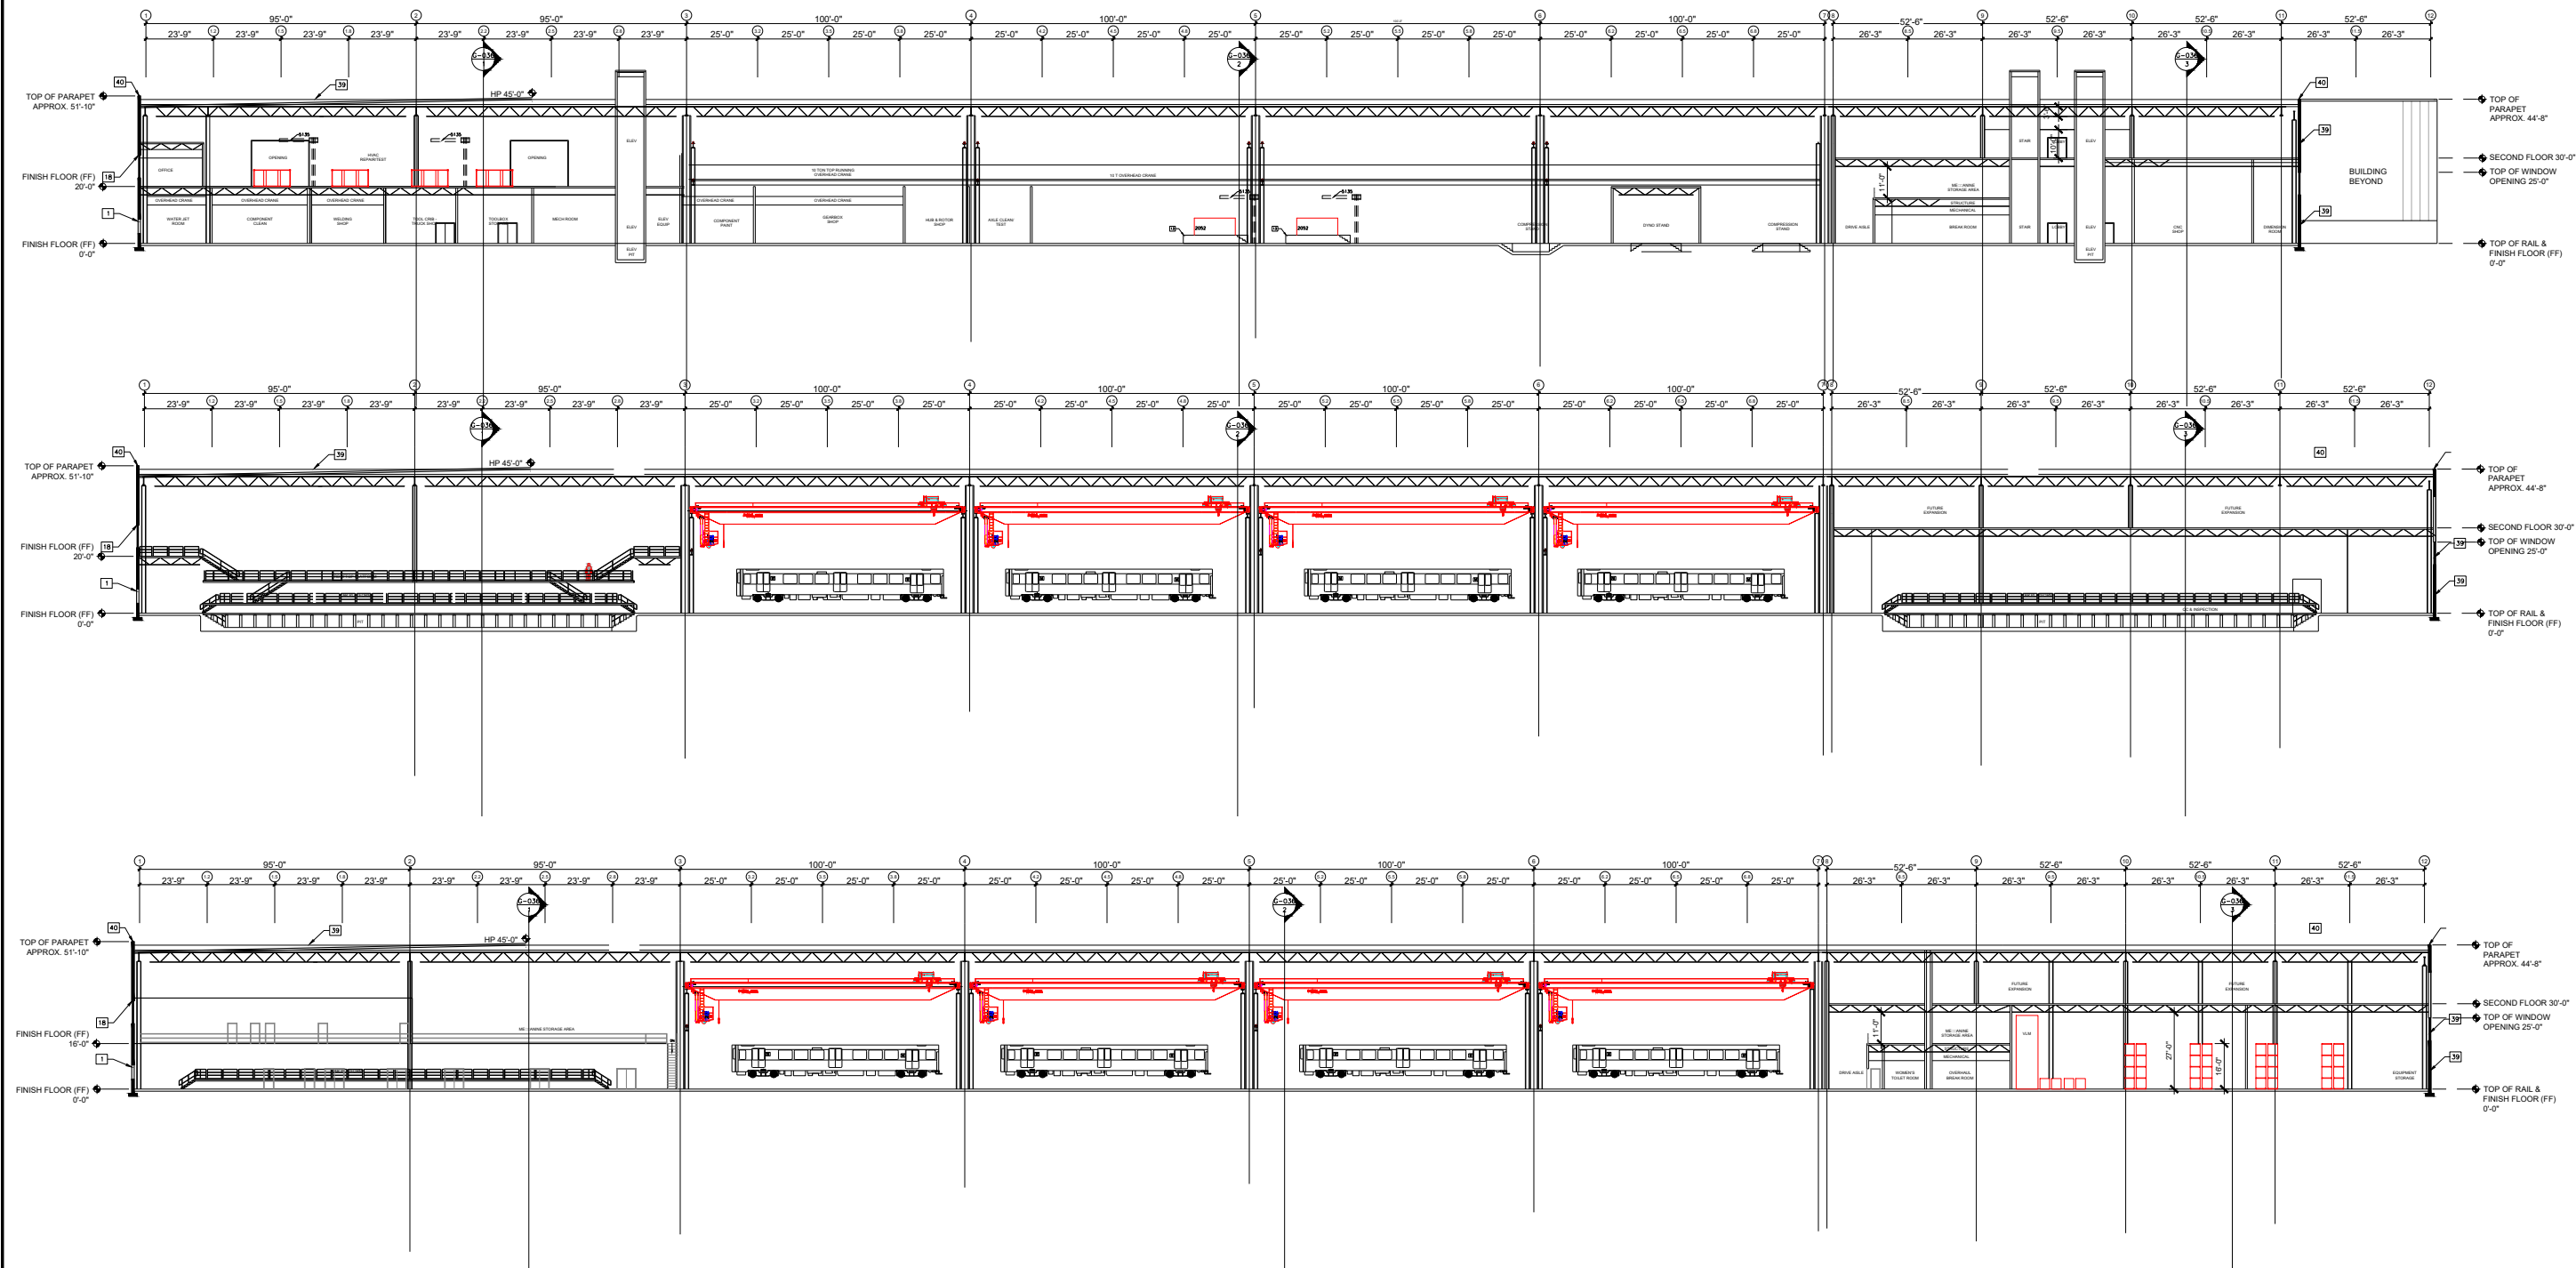

KEY PLAN

CONTRACT NO.
XXXXXXX

DESIGNED	ASI	9-21-2018
		DATE
DRAWN	AH	9-21-2018
		DATE
CHECKED	MNG	9-21-2018
		DATE
APPROVED	ASI	9-21-2018
		DATE

REFERENCE DRAWINGS	
NUMBER	DESCRIPTION

REVISIONS			
DATE	BY	DESCRIPTION	



WASHINGTON METROPOLITAN AREA TRANSIT AUTHORITY

DEPARTMENT OF TRANSIT INFRASTRUCTURE AND ENGINEERING SERVICES
OFFICE OF MAJOR CAPITAL PROJECTS

SUBMITTED 9/21/2018 DATE APPROVED CHIEF ENGINEER DATE

HEAVY REPAIR & OVERHAUL FACILITY

ARCHITECTURE LONG SECTIONS
PENNSY DRIVE

SCALE 1" = 30'-0"

DRAWING NO. HR-A-301

SHEET NO. 24 of 24